

PROJECT TEAM ABBREVIATIONS

OWNER/ TENANT  
SKAGIT COUNTY  
1800 CONTINENTAL PL.  
MOUNT VERNON, WA 98273  
PHONE: (360) 416-1179  
EMAIL: khansen@co.skagit.wa.us  
CONTACT: KEN HANSEN


ARCHITECT  
CARLETTI ARCHITECTS, P.S.  
116 E FIR STREET, SUITE A  
MOUNT VERNON, WA 98273  
PHONE: (360) 424-0394  
FAX: (360) 424-5726  
EMAIL: tom@carlettiarchitects.com  
CONTACT: TOM THEISEN

CONTRACTOR  
T.B.D.  
-  
- WA -  
PHONE: (XXX) XXX-XXXX  
FAX: (XXX) XXX-XXXX  
EMAIL: XXX@XXX.com  
CONTACT: -

|           |                              |      |                 |
|-----------|------------------------------|------|-----------------|
| ABV       | ABOVE                        | JNT  | JOINT           |
| AFF       | ABOVE FINISH FLOOR           | MO   | MASONRY OPENING |
| AC TILE   | ACOUSTICAL TILE              | MFR  | MANUFACTURE     |
| ACP       | ACOUSTICAL CEILING PANEL     | MATL | MATERIAL        |
| ACT       | ACTUAL                       | MAX  | MAXIMUM         |
| AL        | ALUMINUM                     | MECH | MECHANICAL      |
| ARCH      | ARCHITECTURAL                | MTL  | METAL           |
| A TILE    | ASPHALT TILE                 | MIN  | MINIMUM         |
| AVG       | AVERAGE                      | MUL  | MULLION         |
|           |                              | MAR  | MARBLE          |
| BFF       | BOTTOM FINISH FLOOR          |      |                 |
| BLKG      | BLOCKING                     |      |                 |
| BR        | BRICK                        |      |                 |
| BOS       | BOTTOM OF STRUCTURE          |      |                 |
|           |                              |      |                 |
| CPT       | CARPET                       |      |                 |
| CLG       | CEILING                      |      |                 |
| CEM       | CEMENT                       |      |                 |
| ℄         | CENTER LINE                  |      |                 |
| C TO C    | CENTER TO CENTER             |      |                 |
| CT        | CERAMIC TILE                 |      |                 |
| CLO       | CLOSET                       |      |                 |
| CW        | COLD WATER                   |      |                 |
| COL       | COLUMN                       |      |                 |
| CONC      | CONCRETE                     |      |                 |
| CMU       | CONCRETE MASONRY UNIT        |      |                 |
| CONST     | CONSTRUCTION                 |      |                 |
| CONT      | CONTINUOUS                   |      |                 |
| COORD     | COORDINATE                   |      |                 |
| COR       | CORRIDOR                     |      |                 |
| CFM       | CUBIC FEET PER MINUTE        |      |                 |
|           |                              |      |                 |
| DTL       | DETAIL                       |      |                 |
| DIA       | DIAMETER                     |      |                 |
| DIM       | DIMENSION                    |      |                 |
| DO        | DITTO                        |      |                 |
| DR        | DOOR                         |      |                 |
| DN        | DOWN                         |      |                 |
| D.S.      | DOWNSPOUT                    |      |                 |
| DWG       | DRAWING                      |      |                 |
| DF        | DRINKING FOUNTAIN            |      |                 |
|           |                              |      |                 |
| EA        | EACH                         |      |                 |
| ELEC      | ELECTRICAL                   |      |                 |
| ELEV. EL  | ELEVATION                    |      |                 |
| EQ        | EQUAL                        |      |                 |
| (E) EXIST | EXISTING                     |      |                 |
| EXT       | EXTERIOR                     |      |                 |
|           |                              |      |                 |
| FO        | FACE OF, FINISH OPENING      |      |                 |
| FRP       | FIBERGLASS REINF POLYESTERS  |      |                 |
| FIN       | FINISH                       |      |                 |
| FAAP      | FIRE ALARM ANNUNCIATOR PANEL |      |                 |
| FD        | FIRE DAMPER                  |      |                 |
| FE        | FIRE EXTINGUISHER            |      |                 |
| FF        | FACTORY FINISH               |      |                 |
| FF        | FINISH FLOOR                 |      |                 |
| FRT       | FIRE RETARDANT TREATED       |      |                 |
| FLASH     | FLASHING                     |      |                 |
| FLR       | FLOOR                        |      |                 |
| F.A.      | FLUID-APPLIED                |      |                 |
| FND       | FOUNDATION                   |      |                 |
| FOIC      | FURNISHED BY OWNER           |      |                 |
|           | INSTALLED BY CONTRACTOR      |      |                 |
| FOIO      | FURNISHED BY OWNER           |      |                 |
|           | INSTALLED BY OWNER           |      |                 |
| FCIC      | FURNISHED BY CONTRACTOR      |      |                 |
|           | INSTALLED BY CONTRACTOR      |      |                 |
|           |                              |      |                 |
| GA        | GAUGE                        |      |                 |
| GALV      | GALVANIZED                   |      |                 |
| GAP       | GENERATOR ALARM PANEL        |      |                 |
| GL        | GLASS                        |      |                 |
| GSB       | GYPSUM WALLBOARD             |      |                 |
|           |                              |      |                 |
| HC        | HANDICAP                     |      |                 |
| HDWE      | HARDWARE                     |      |                 |
| HP        | HEAT PUMP                    |      |                 |
| HT        | HEIGHT                       |      |                 |
| HM        | HOLLOW METAL                 |      |                 |
| HOR       | HORIZONTAL                   |      |                 |
| HB        | HOSE BIB                     |      |                 |
| HW        | HOT WATER                    |      |                 |
| HWT       | HOT WATER TANK               |      |                 |
| HMD       | HOLLOW METAL DOOR            |      |                 |
| HMF       | HOLLOW METAL FRAME           |      |                 |
|           |                              |      |                 |
| ID        | INSIDE DIMENSION             |      |                 |
| INSUL     | INSULATION                   |      |                 |
| INT       | INTERIOR                     |      |                 |

GENERAL NOTES

- IN GENERAL, PLAN DIMENSIONS SHOWN ARE TO FACE OF STUD OR FACE OF CONCRETE, UNLESS OTHERWISE NOTED. DO NOT SCALE THESE DRAWINGS. USE CALCULATED DIMENSIONS ONLY. VERIFY ALL DIMENSIONS DATUM, AND LEVELS PRIOR TO CONSTRUCTION. NOTIFY ARCHITECT IMMEDIATELY OF ANY DISCREPANCIES.
- CONTRACTOR SHALL VERIFY ALL EXISTING CONDITIONS PRIOR TO INITIATING THE WORK. NOTIFY ARCHITECT OF ANY DISCREPANCIES.
- ALL WORK SHALL COMPLY WITH THE 2021 IBC, IEBC, IPC, UPC, IMC AS AMENDED BY WASH. STATE. PROJECT SHALL ALSO COMPLY WITH THE 2021 NREC AND THE VIACO CODES. PROJECT SHALL ALSO COMPLY W/ JURISDICTIONAL CODE AMENDMENTS BY THE LOCAL AGENCY. CONTRACTOR IS RESPONSIBLE FOR OBTAINING NECESSARY PERMITS & INSPECTIONS TO COMPLETE THE WORK. CONTRACTOR TO HAVE CURRENT VALID CITY OR COUNTY BUSINESS LICENSE PRIOR TO ISSUANCE OF PERMIT, WHEN REQUIRED BY LAW.
- ERRORS, OMISSIONS, AND DISCREPANCIES, IF ANY, SHALL BE REFERRED TO THE ARCHITECT IMMEDIATELY FOR DIRECTION OF HOW TO PROCEED.
- VERIFY ALL ROUGH-IN DIMENSIONS FOR EQUIPMENT PROVIDED IN THE CONTRACT BY OTHERS PROVIDE ALL BLOCK-OUTS, BLOCKING, BACKING AND JACKS REQUIRED FOR DUCTS, PIPES, CONDUITS, EQUIPMENT, FIXTURES, AND CABINETS. VERIFY SIZE AND LOCATION. DO NOT SIGNIFICANTLY VARY OR MODIFY THE WORK SHOWN, EXCEPT UPON WRITTEN INSTRUCTIONS OF THE ARCHITECT.
- VERIFY LOCATION OF ALL EXISTING UTILITIES INCLUDING BUT NOT LIMITED TO, SEWER, SEPTIC, WATER, GAS, POWER, AND TELEPHONE. CAP, MARK AND PROTECT.
- DETAILS ARE INTENDED TO SHOW THE INTENT OF THE DESIGN. MINOR MODIFICATION MAY BE REQUIRED TO SUIT THE FIELD DIMENSIONS OR CONDITIONS AND SUCH MODIFICATIONS SHALL BE INCLUDED AS PART OF THE WORK OF THE CONTRACT.
- PROVIDE CLOSURE, MEETING THE REQUIREMENTS OF ALL GOVERNING AUTHORITIES, AT RATED PARTITIONS, FLOORS, CEILINGS, AND ROOF LOCATIONS. ALL REQUIRED FIRE-RATED PARTITIONS SHALL BE CONTINUOUS FROM FLOOR TO UNDERSIDE OF STRUCTURE ABOVE.
- THE CONTRACTOR SHALL CONSULT PLANS OF ALL TRADES, INCLUDING DESIGN-BUILD DOCUMENTS REQUIRED BY CONTRACT DOCUMENTS, TO VERIFY SIZE, WEIGHT, POWER, LOCATION AND OTHER REQUIREMENTS AND LOCATION OF THOSE ITEMS TO BE INSTALLED PRIOR TO COMMENCEMENT OF WORK.
- NO BUILDING OR PORTION OF A BUILDING SHALL BE OCCUPIED OR USED FOR STORAGE PRIOR TO THE ISSUANCE OF THE CERTIFICATE OF OCCUPANCY. NO EXCEPTIONS.
- SEPERATE PERMITS ARE REQUIRED FOR PLUMBING, MECH., ELEC., FIRE SPRINKLER, FIRE ALARM SYSTEMS & SIGNAGE.
- ALL EXPOSED EXTERIOR SHEET METAL SHALL BE GALVANIZED, PRIMED AND PAINTED.
- ALL WOOD IN CONTACT W/ CONCRETE SHALL BE PRESSURE TREATED. PRESSURE TREATED WOOD SHALL BE USED FOR WOOD MEMBERS WHICH FORM THE STRUCTURAL SUPPORT OF BALCONIES, DECKS, OR PORCHES ETC. WHEN SUCH MEMBERS ARE EXPOSED TO THE WEATHER.
- SLOPE ALL DECKS, PATIOS, AND WALKWAYS AWAY FROM BUILDING MINIMUM OF 1/8"/FT FOR POSITIVE DRAINAGE.
- PROVIDE EXPANSION JOINTS IN ALL CONCRETE SLABS AS REQUIRED TO PREVENT CRACKING. SAW CUT ALL SLABS AS REQ'D.
- PROVIDE FIREBLOCKING, DRAFTSTOPS, AND FIRESTOPS IN ATTICS, FLOORS, AND WALL CAVITIES AS REQUIRED PER THE IBC.
- ROOF DRAINS, AND OVERFLOW DRAINS SHALL COMPLY W/ THE IPC & IBC. AND WALL CAVITIES AS REQUIRED PER THE IBC.
- DRAWINGS INDICATE GENERAL AND TYPICAL DETAILS OF CONSTRUCTION. WHERE CONDITIONS ARE NOT SPECIFICALLY INDICATED BUT ARE OF SIMILAR CHARACTER TO DETAILS SHOWN, SIMILAR DETAILS OF CONSTRUCTION SHALL BE USED SUBJECT TO REVIEW BY THE ARCHITECT.
- CONTRACTOR SHALL BE RESPONSIBLE FOR ALL SAFETY PRECAUTIONS AND THE MEANS, METHODS, TECHNIQUES, SEQUENCES OR PROCEDURES REQUIRED TO PERFORM THE WORK.
- CONTRACTOR SHALL RETAIN ONE SET OF THE PLANS TO NOTE AND DOCUMENT ALL CHANGES DURING CONSTRUCTION. THE SET SHALL BE A PART OF THE CONTRACTOR'S CLOSE-OUT PACKAGE TO THE OWNER. CLOSE-OUT PACKAGE SHALL INCLUDE:  
(I) SET OF SHOP DRAWINGS, PRODUCT LITERATURE, EQUIPMENT WARRANTEE MANUALS.
- CONTRACTOR SHALL PROVIDE SOLID BLOCKING, UNLESS NOTED OTHERWISE AS REQUIRED FOR NAILING OF ALL INTERIOR AND EXTERIOR TRIMS, FINISHES, AND FIXTURES. THE CONTRACTOR SHALL PROVIDE FOR ALL THE NECESSARY FRAMING AND BRACING FOR THE INSTALLATION OF OWNER FURNISHED ITEMS SUCH AS SIGNAGE, MENU BOARDS ETC.
- WHERE EXISTING WORK IS DAMAGED, CUT, OR DEFACED DUE TO PERFORMANCE OF NEW WORK, THE CONTRACTOR SHALL PATCH AND REPAIR SAME TO MATCH ADJOINING SURFACES. REPAIRED FINISHES SHALL BE EXTENDED TO THE NEAREST VISUAL BREAK LINES SUCH AS CORNERS, CEILING LINES, TOP OF BASE OR SIMILAR.
- THESE DRAWINGS ARE THE EXCLUSIVE PROPERTY OF THE ARCHITECT AND MAY BE REPRODUCED ONLY WITH THE WRITTEN PERMISSION OF THE ARCHITECT. AUTHORIZED REPRODUCTIONS MUST BEAR THE NAME OF THE ARCHITECT.

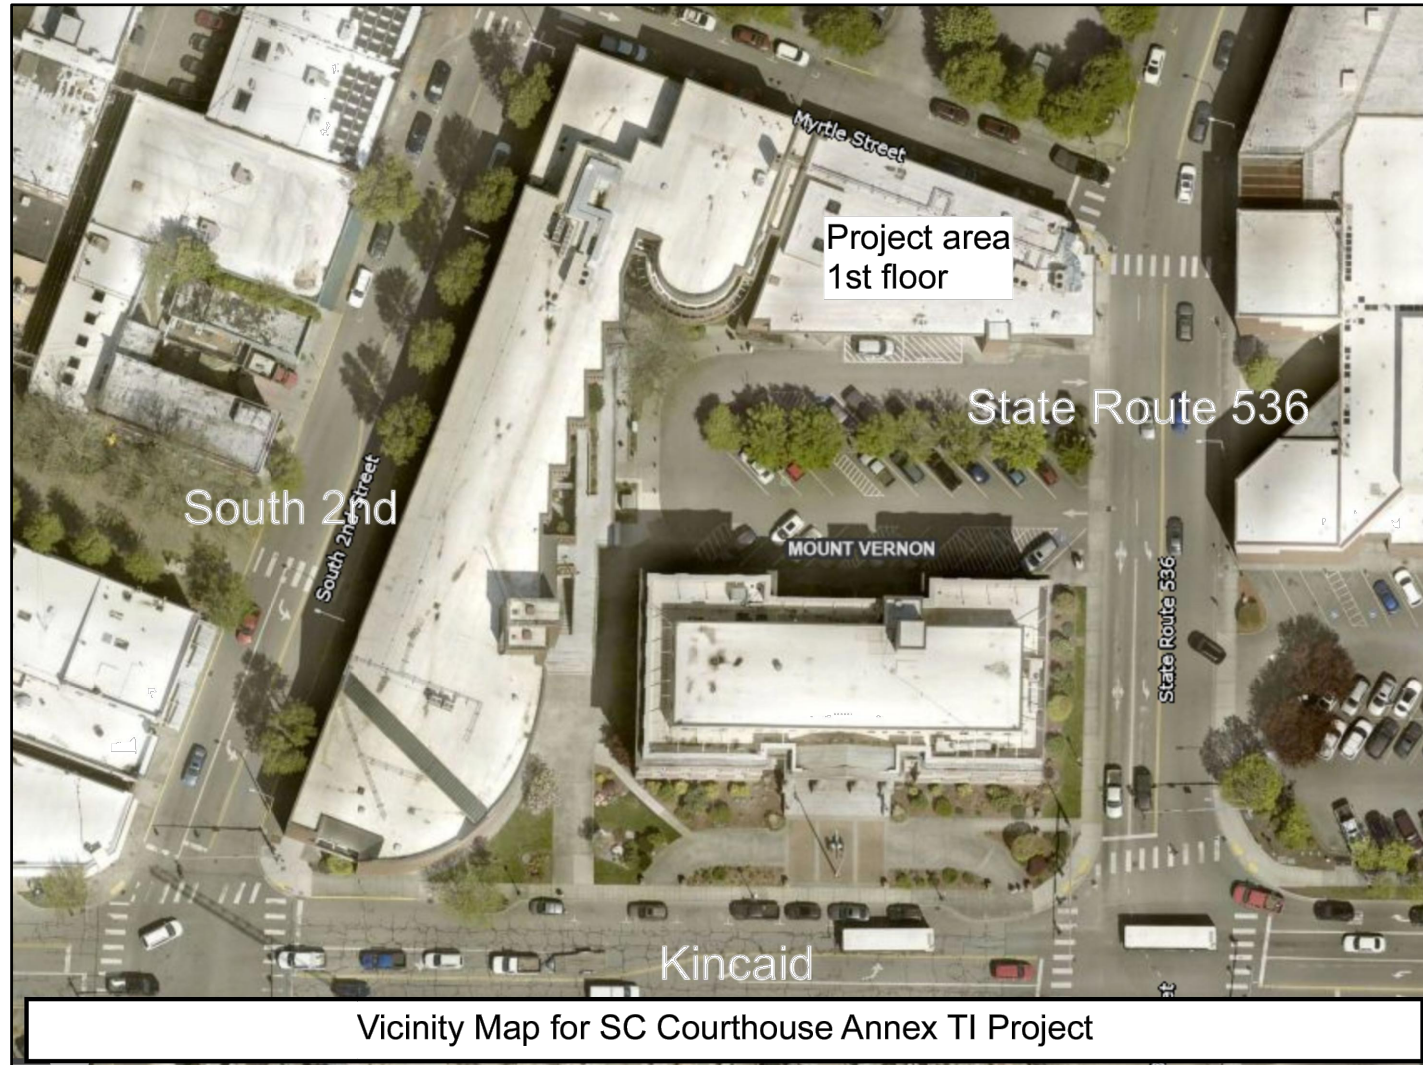

VICINITY MAP

NO SCALE

PROJECT DATA

PROPERTY INFORMATION

|                  |                                                |
|------------------|------------------------------------------------|
| PROPERTY ADDRESS | 700 SOUTH 2ND STREET<br>MOUNT VERNON WA, 98273 |
| BUILDING CODE    | 2021 IBC/IEBC/IFC/ICC/ANSI A117.1-2019         |
| ENERGY CODE      | 2021 WASHINGTON STATE NREC                     |
| FIRE SPRINKLERS  | NONE                                           |
| FIRE ALARM       | YES, NO CHANGES THIS PROJECT                   |

PARCEL#

26482

LEGAL DESCRIPTION

TAX 28-30, DK 3, BEG ON S LI MYRTLE ST 100FT E 20DEG S FR E LI 2ND ST TH ELY ALG S LI MYRTLE ST 113 3/4FT TO W LI 3RD ST TH S ALG W LI 3RD ST TAP 244.5FT W & 224.5 FT N OF SE C GOVERNMENT LOT 7, SECTION 19, TOWNSHIP 34 NORTH, RANGE 4 EAST, W.M., TH N 8IDEG 54FT W 78.24FT TH N 7.82FT TH W TAP 100FT ELY FR E LI 2ND ST MEAS AT R/A THFR TH N 20 DEG E TPOB..

ZONING

|                 |                    |
|-----------------|--------------------|
| SETBACKS        | EXISTING (NO WORK) |
| BUILDING HEIGHT | EXISTING (NO WORK) |
| LOT ACRES       | EXISTING           |

PARKING CALCULATION

T.I. ONLY, NO CHANGE

LANDSCAPING REQUIREMENTS

T.I. ONLY, NO CHANGE

BUILDING CODE DATA

OCCUPANCY: B (EXISTING, NO CHANGE)

TYPE OF CONSTRUCTION: 11B (EXISTING, NO CHANGE)

|                      |           |
|----------------------|-----------|
| SIZE                 |           |
| FIRST FLOOR T.I.     | 5,800 SF  |
| FIRST FLOOR NO WORK  | 950 SF    |
| SECOND FLOOR NO WORK | 6,750 SF  |
| TOTAL BUILDING       | 13,500 SF |

DRAWING INDEX

ARCHITECTURAL


|       |                                   |
|-------|-----------------------------------|
| A-0.0 | COVER SHEET AND GENERAL NOTES     |
| A-2.0 | LIFE SAFETY PLAN                  |
|       | DEMOLITION PLAN                   |
| A-2.1 | PROPOSED KEY FLOOR PLAN           |
|       | PROPOSED FLOOR FINISHES           |
| A-2.2 | REFLECTED CEILING DEMOLITION PLAN |
|       | PROPOSED FLOOR PLAN               |
|       | PROPOSED REFLECTED CEILING PLAN   |
| A-2.3 | PROPOSED MECHANICAL PLAN          |
|       | PROPOSED ELECTRICAL PLAN          |
|       | WALL SECTION                      |
| A-2.4 | ROOM FINISH SCHEDULE              |
|       | DOOR SCHEDULE                     |



CARLETTI ARCHITECTS P.S.  
architecture, planning, interior design

116 EAST FIR STREET  
SUITE A  
MOUNT VERNON, WA. 98273



Phone: (360) 424-0394  
Fax: (360) 424-5726

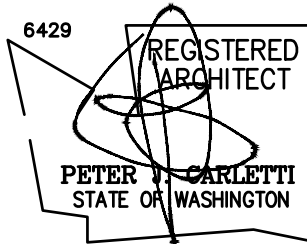

SKAGIT COUNTY COURTHOUSE  
ANNEX FIRST FLOOR  
T.I.  
605 SOUTH THIRD STREET  
MOUNT VERNON, WA 98273

CLIENT CONTACT: KEN HANSEN  
PHONE: 360-416-1179  
EMAIL: khansen@co.skagit.wa.us

SYMBOLS

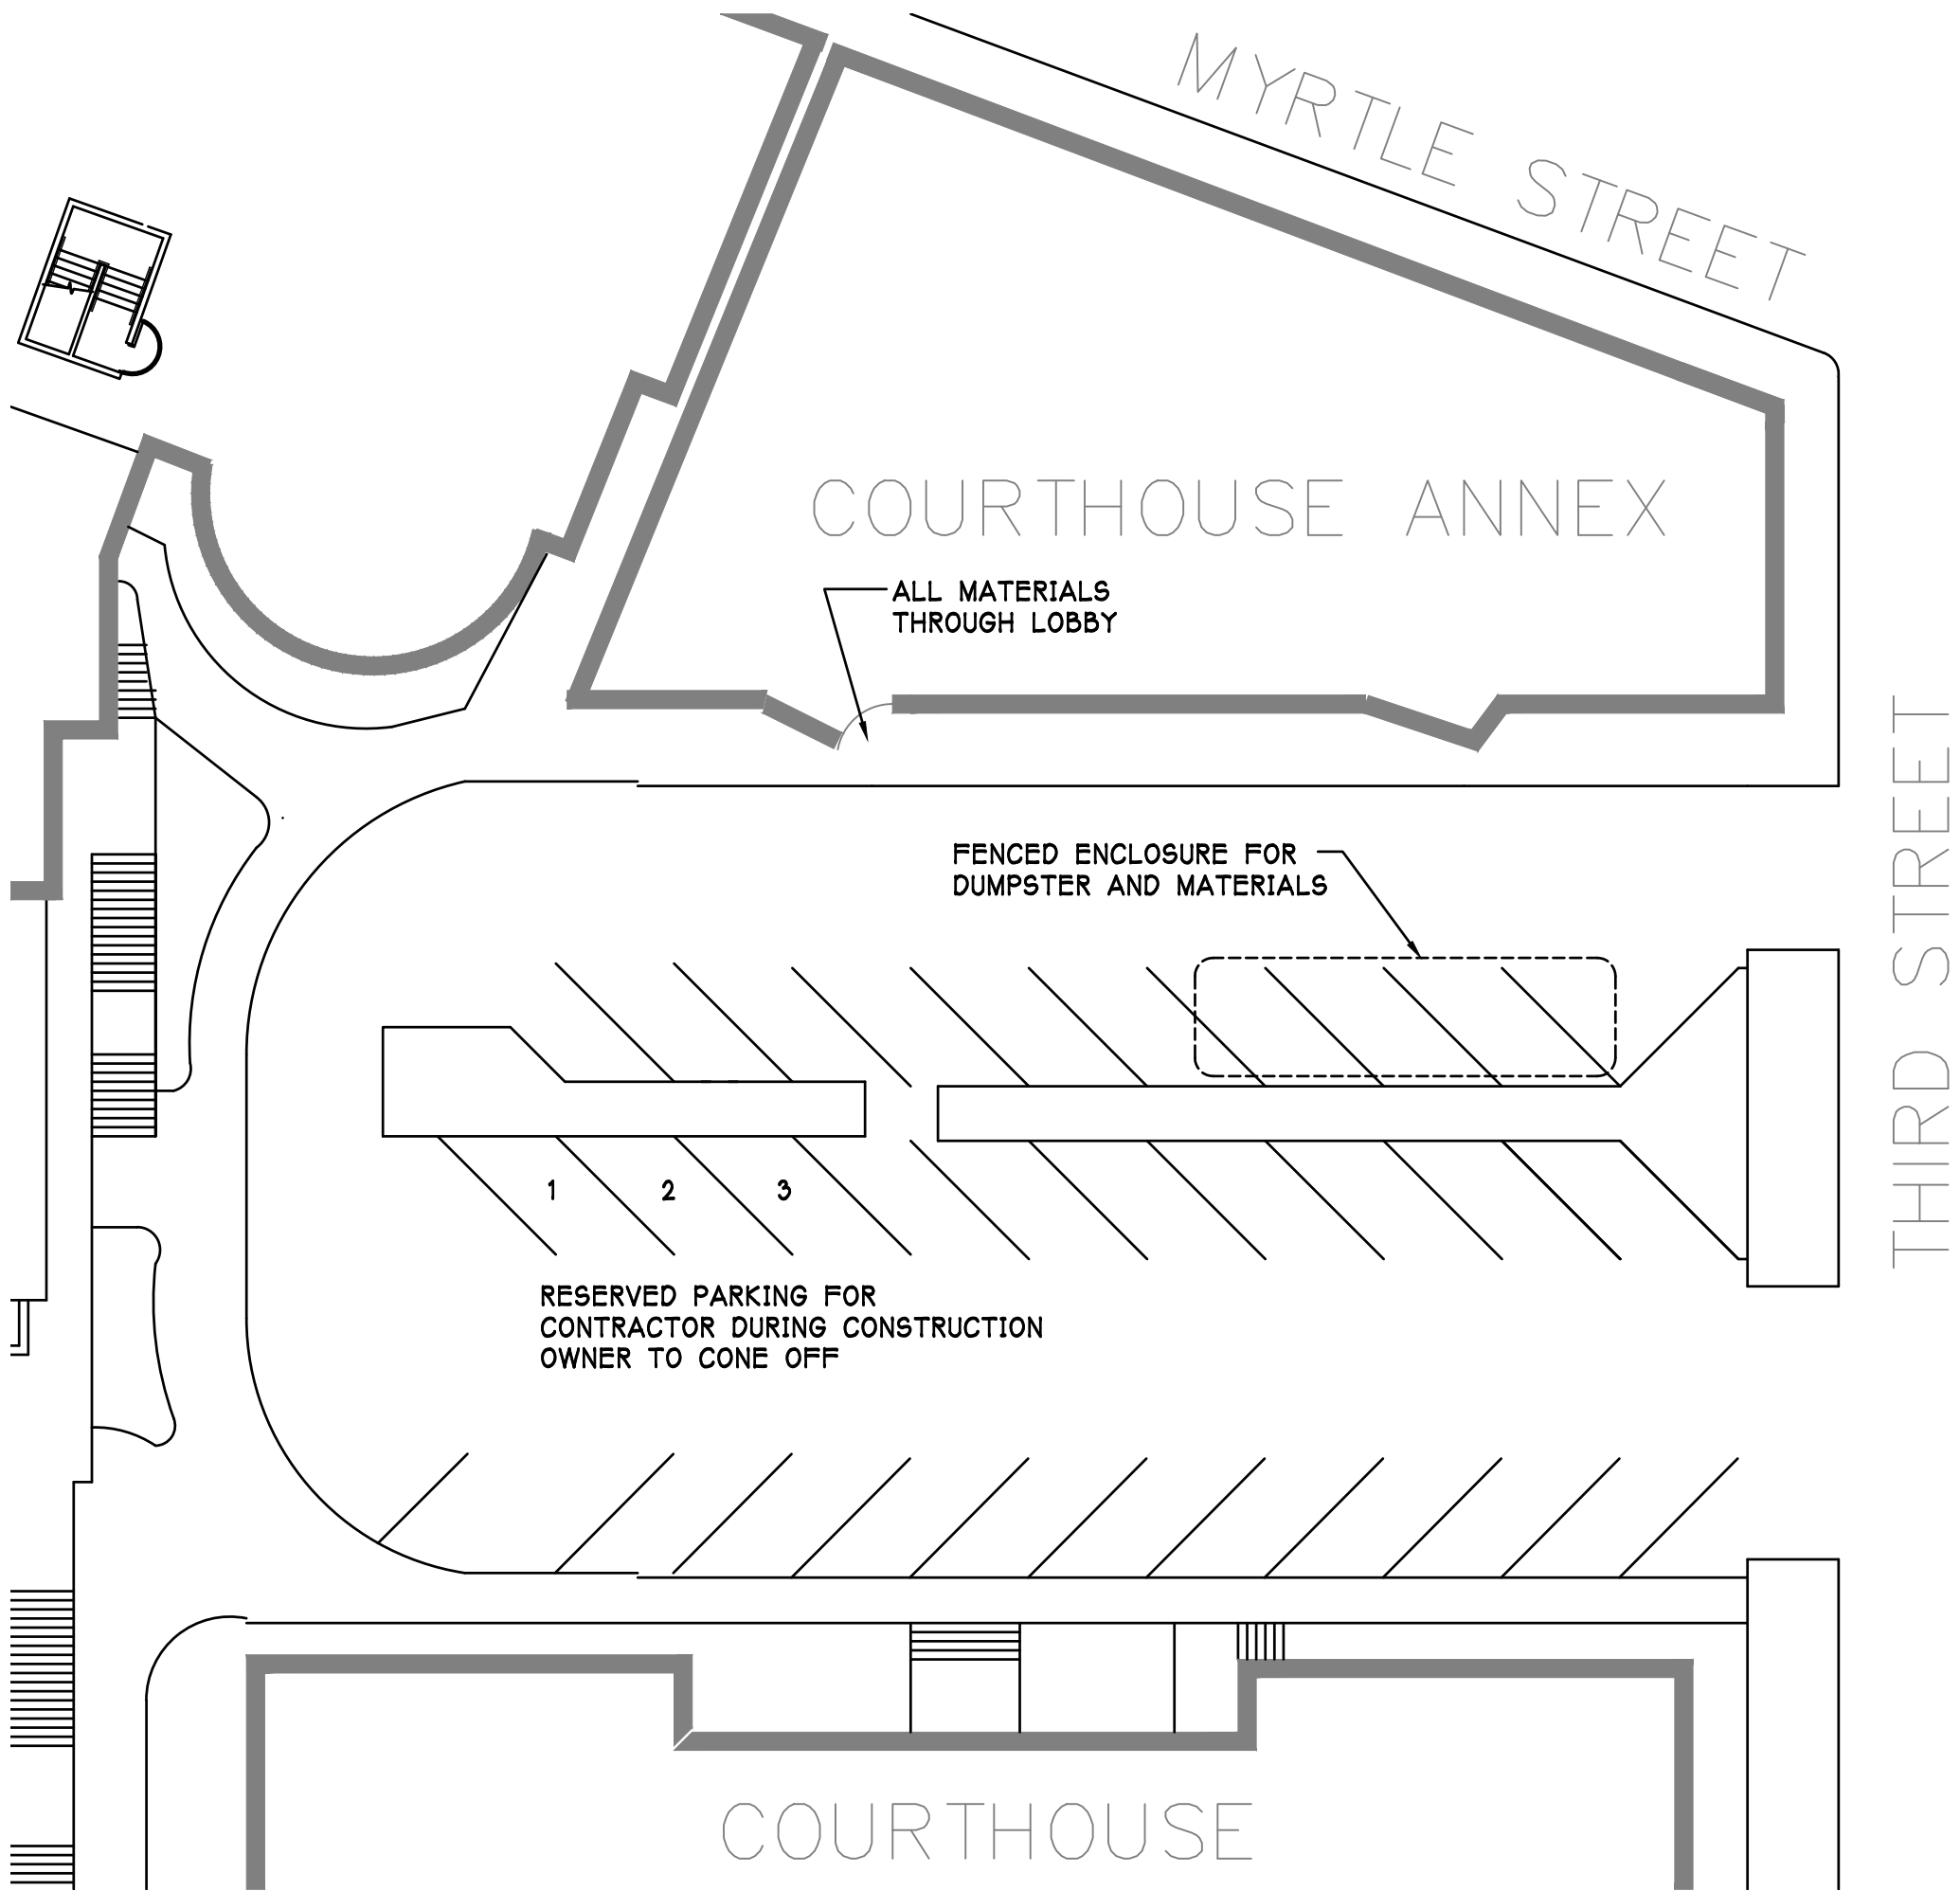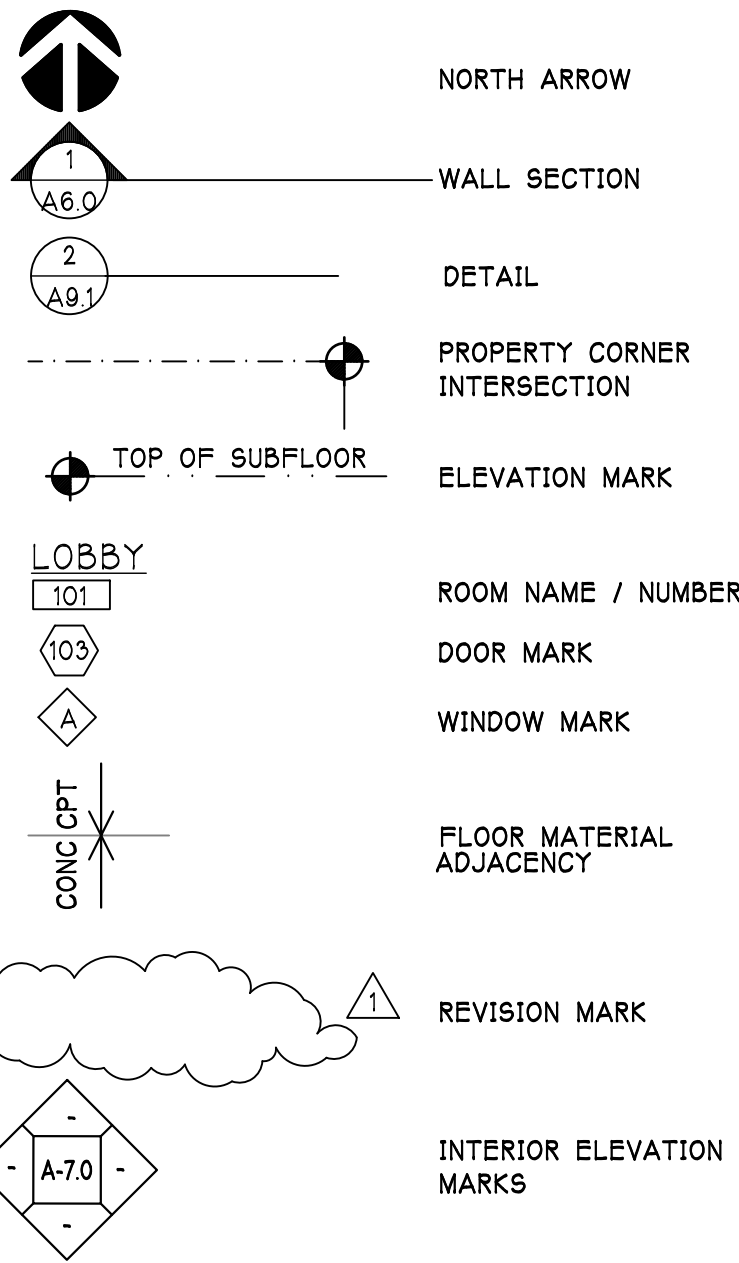

CONTRACTOR PARKING AND STAGING PLAN


1" = 20'-0"

PJC  
PROJECT ARCHITECT:  
IC  
DRAWN BY:  
PJC  
CHECKED BY:  
SEPTEMBER 17, 2024  
DATE  
24-821 SC ANNEX OFFICE BASE  
COMPUTER FILE NAME

A=0.0



COPYRIGHT 2024 CARLETTI ARCHITECTS, P.S.



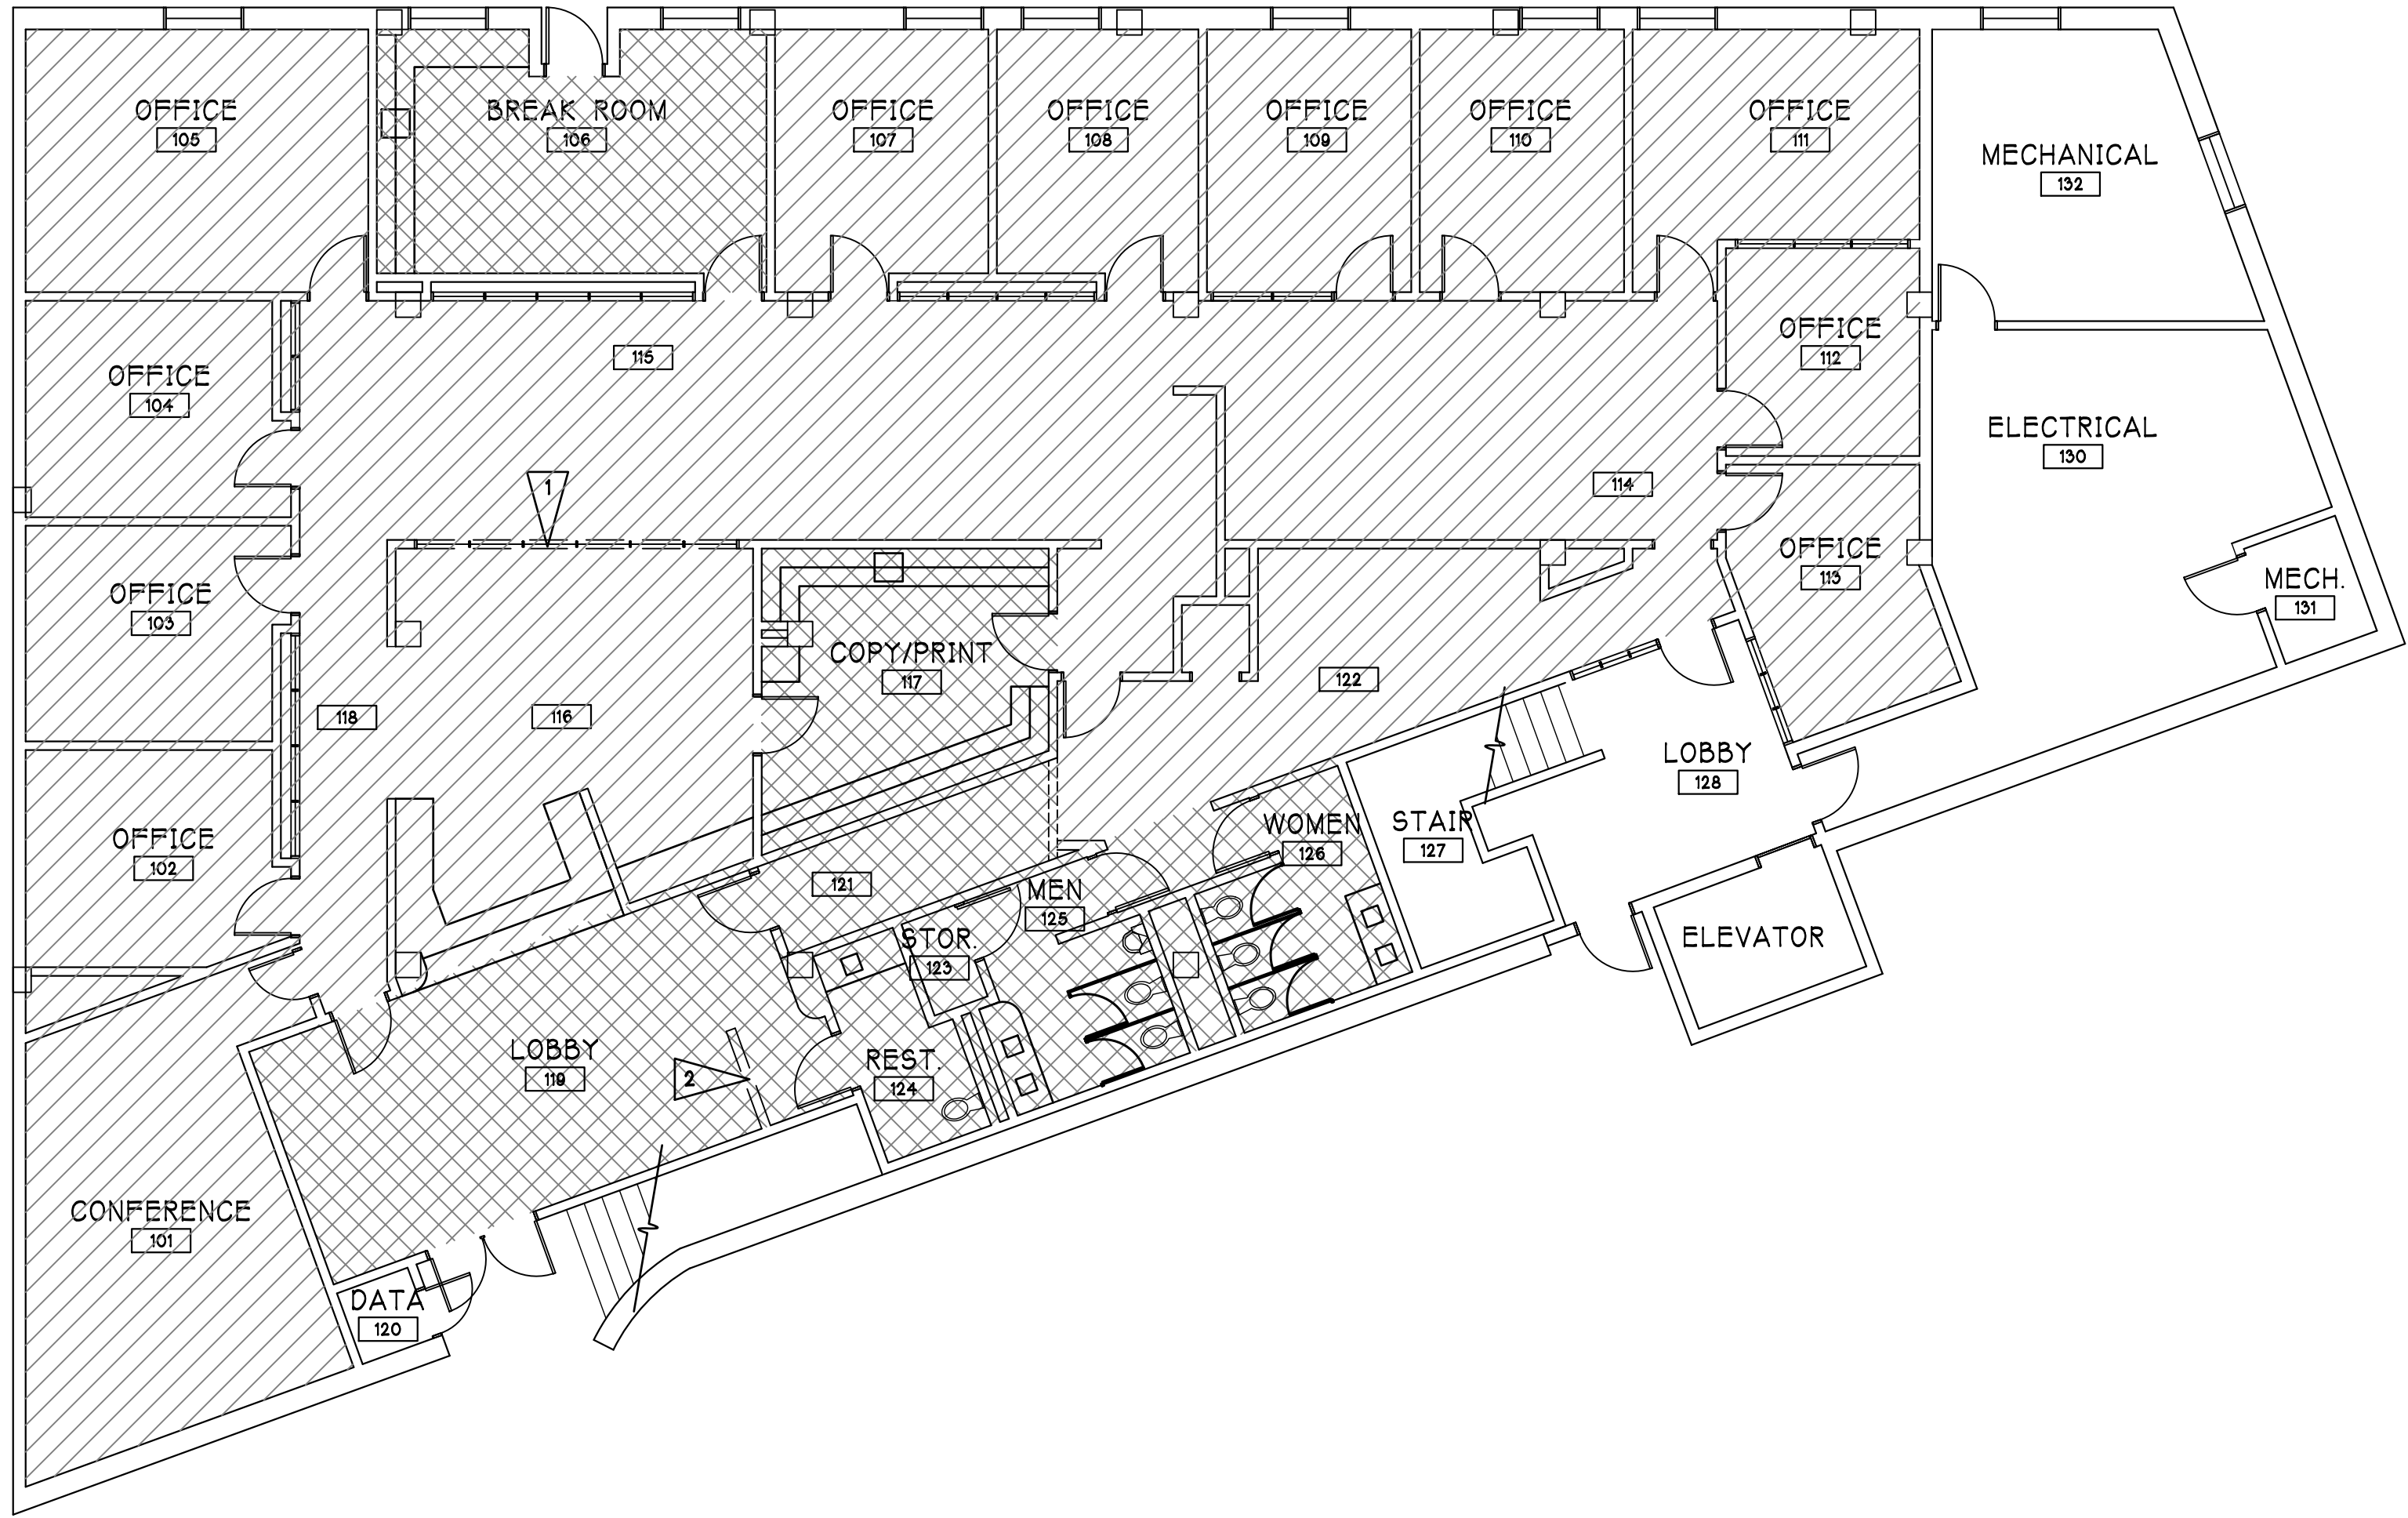


EXISTING CONDITIONS AND DEMOLITION PLAN

1/8"=1'-0"

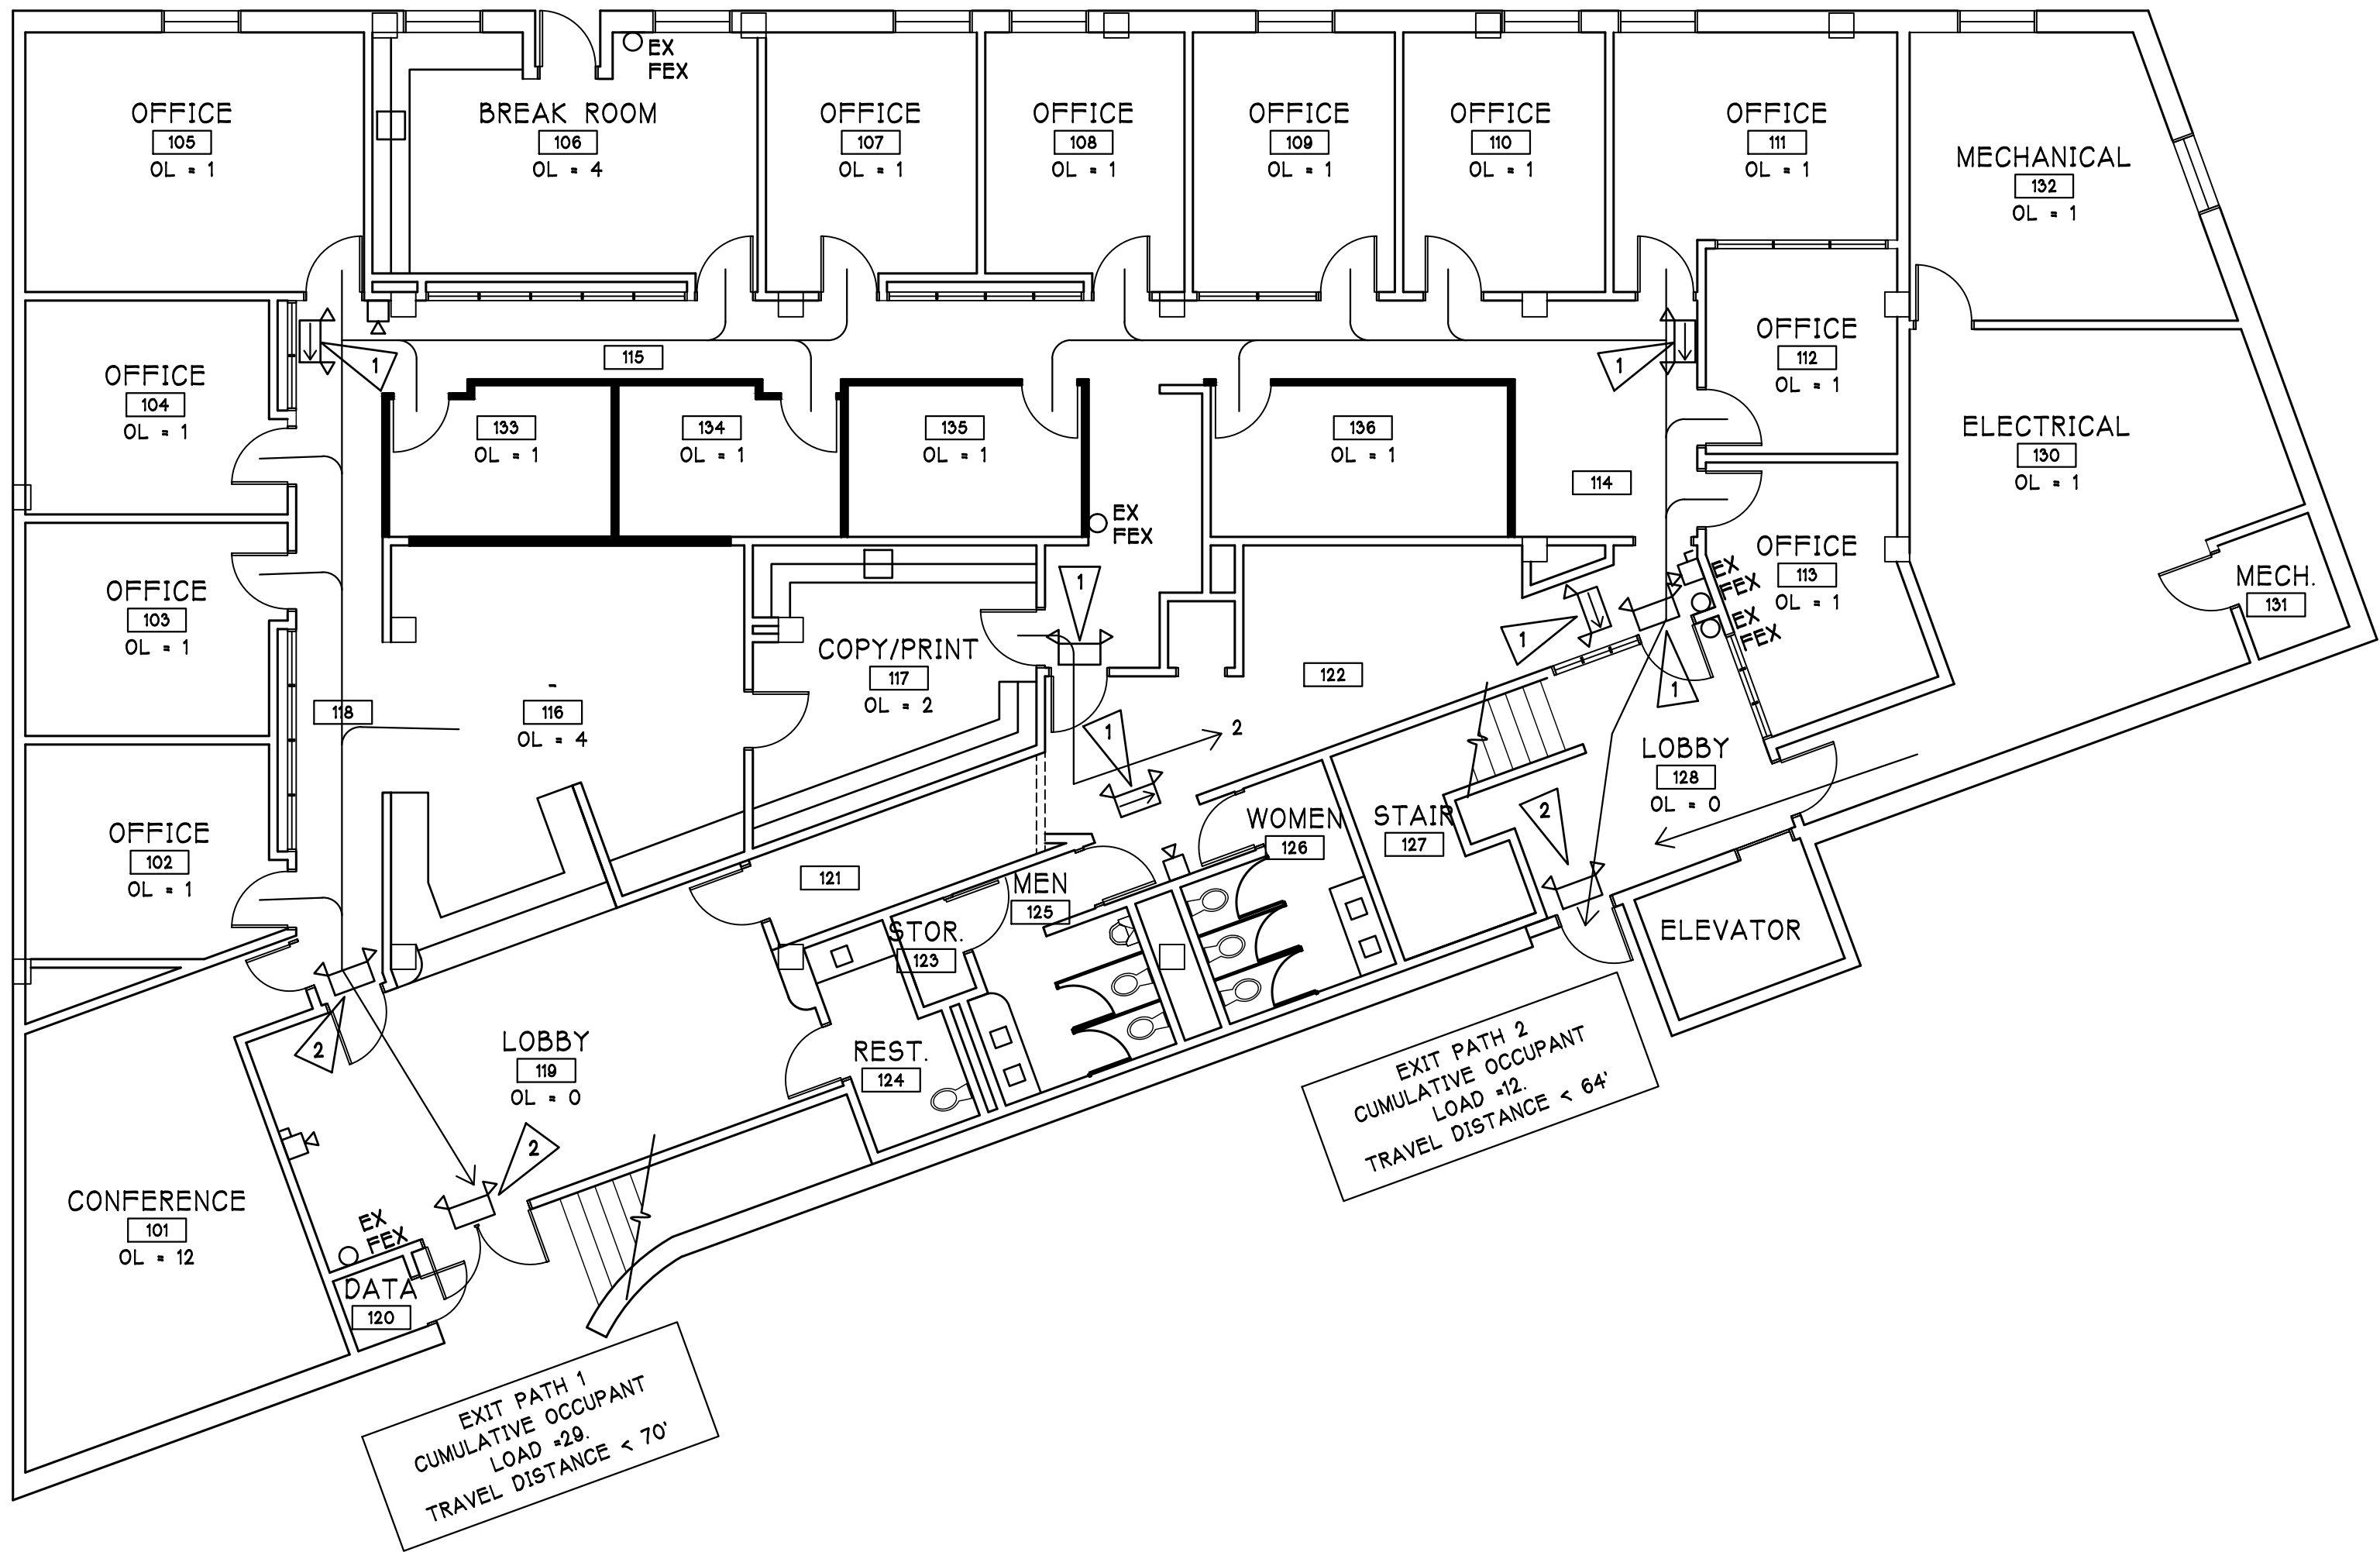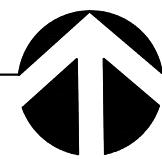

LIFE SAFETY PLAN

1/8"=1'-0"

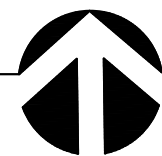

DEMOLITION CONSTRUCTION NOTES:


- 1 REMOVE CARPET AND BASE THIS AREA AND PREPARE FOR NEW CARPET AND BASE.
- 2 REMOVE FLOOR TILE AND BASE THESE AREAS.
- 3 REMOVE RELITES THIS AREA AND PREPARE OPENING FOR INFILL.
- 4 REMOVE WALL AND REPAIR ADJACENT SURFACES.



CARLETTI ARCHITECTS P.S.  
architecture, planning, interior design

116 EAST FIR STREET  
SUITE A  
MOUNT VERNON, WA. 98273

Phone: (360) 424-0394  
Fax: (360) 424-5726

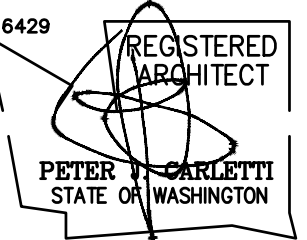

SKAGIT COUNTY COURTHOUSE  
ANNEX FIRST FLOOR  
T.I.  
605 SOUTH THIRD STREET  
MOUNT VERNON, WA 98273

CLIENT CONTACT: KEN HANSEN  
PHONE: 360-416-1179  
EMAIL: khansen@co.skagit.wa.us

PROJECT# 24-821  
PROJECT NUMBER:

REVISIONS: 1  
05/15/25 BID SET

LIFE SAFETY PLAN LEGEND

- 1 NEW EXIT SIGN WITH EMERGENCY LIGHT AND BATTERY BACKUP. DIRECTIONAL ARROW IF INDICATED. MUST COMPLY WITH IBC 1013.1.
- 2 EXISTING EXIT SIGN TO BE REPLACED WITH NEW EXIT SIGN WITH EMERGENCY LIGHT AND BATTERY BACKUP. DIRECTIONAL ARROW IF INDICATED. MUST COMPLY WITH IBC 1013.1.
- EXISTING FIRE ALARM PULL STATION AND HORN.
- EXISTING FIRE ALARM HORN.
- DIRECTION EXIT TRAVEL.
- EXISTING FIRE EXTINGUISHER, 2A 10BC.

LIFE SAFETY NOTES

- PER SECTION 1006.21 TRAVEL DISTANCE TO COMMON PATH OF EGRESS IN UNSPRINKLED BUILDINGS TO BE LESS THAN 75'. THIS PROJECT COMPLIES.
- PER SECTION 1006.21 > 40 OCCUPANTS REQUIRES 2 EXITS. 2 EXITS ARE PROVIDED.
- PER SECTION 1005.1 EGRESS WIDTH PER OCCUPANT SERVED TO BE (20) INCHES PER OCCUPANT WITHOUT A SPRINKLER SYSTEM.
  - EXIT PATH 1 CUMULATIVE OCCUPANT LOAD 29 X .20 = 5.8'
  - EXIT PATH 2 CUMULATIVE OCCUPANT LOAD 12 X .20 = 2.4'
- PER SECTION 1007.1.1 EXITS ARE ALL GREATER THAN 1/2 THE DIAGONAL DISTANCE APART WHERE 2 EXITS ARE REQUIRED.
- EXIT PATHS ARE ASSUMED TO BE RATED, BUT NOT VERIFIED. REGARDLESS, NEW WALLS ALONG EXIT PATH ARE 1 HOUR.
- EXISTING DOORS ALONG EXIST PATHS ARE 20 MINUTE.
- NEW DOORS ARE SPECIFIED TO BE 20 MINUTE.
- NEW WALL ARE ALL 1 HOUR RATED AS PER GA FILE #WP1350 GENERIC.

SHEET TITLE:

LIFE SAFETY PLAN

DEMOLITION PLAN

PJC  
PROJECT ARCHITECT:

IC  
DRAWN BY:

PJC  
CHECKED BY:


SEPTEMBER 17, 2024  
DATE

24-821 SC ANNEX OFFICE BASE  
COMPUTER FILE NAME

A-2.0



COPYRIGHT 2024 CARLETTI ARCHITECTS. P.S.



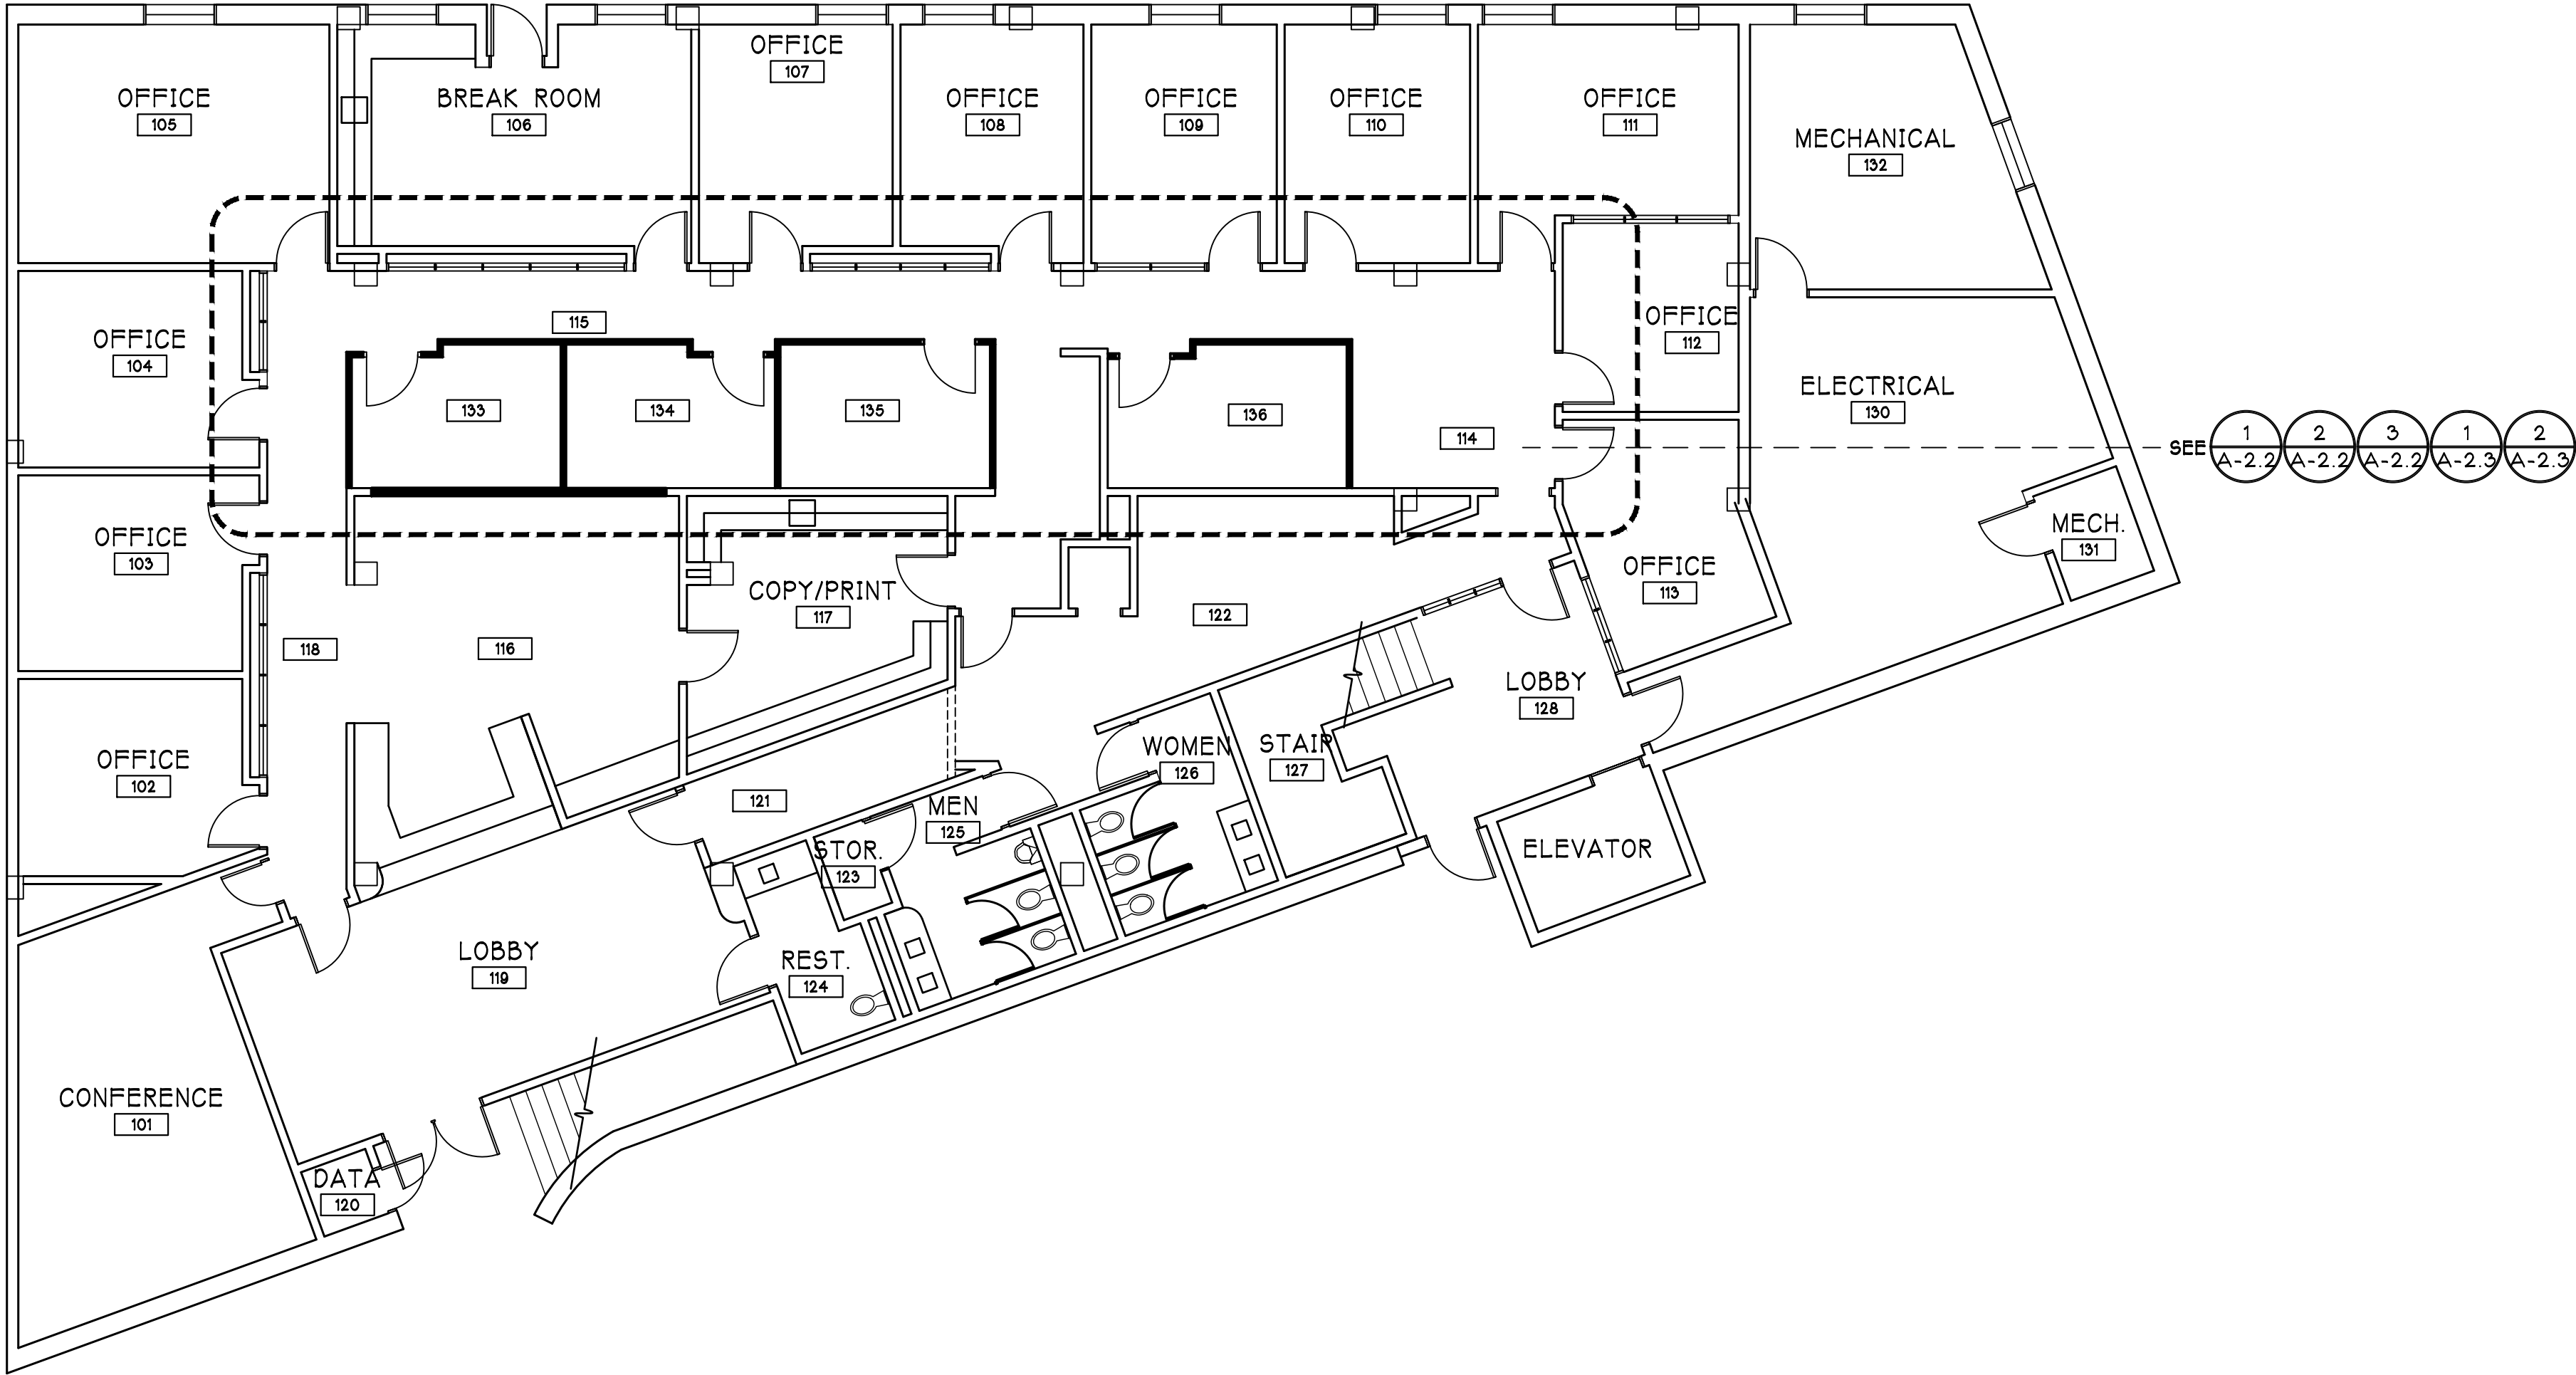


KEY PLAN

1/8"=1'-0"

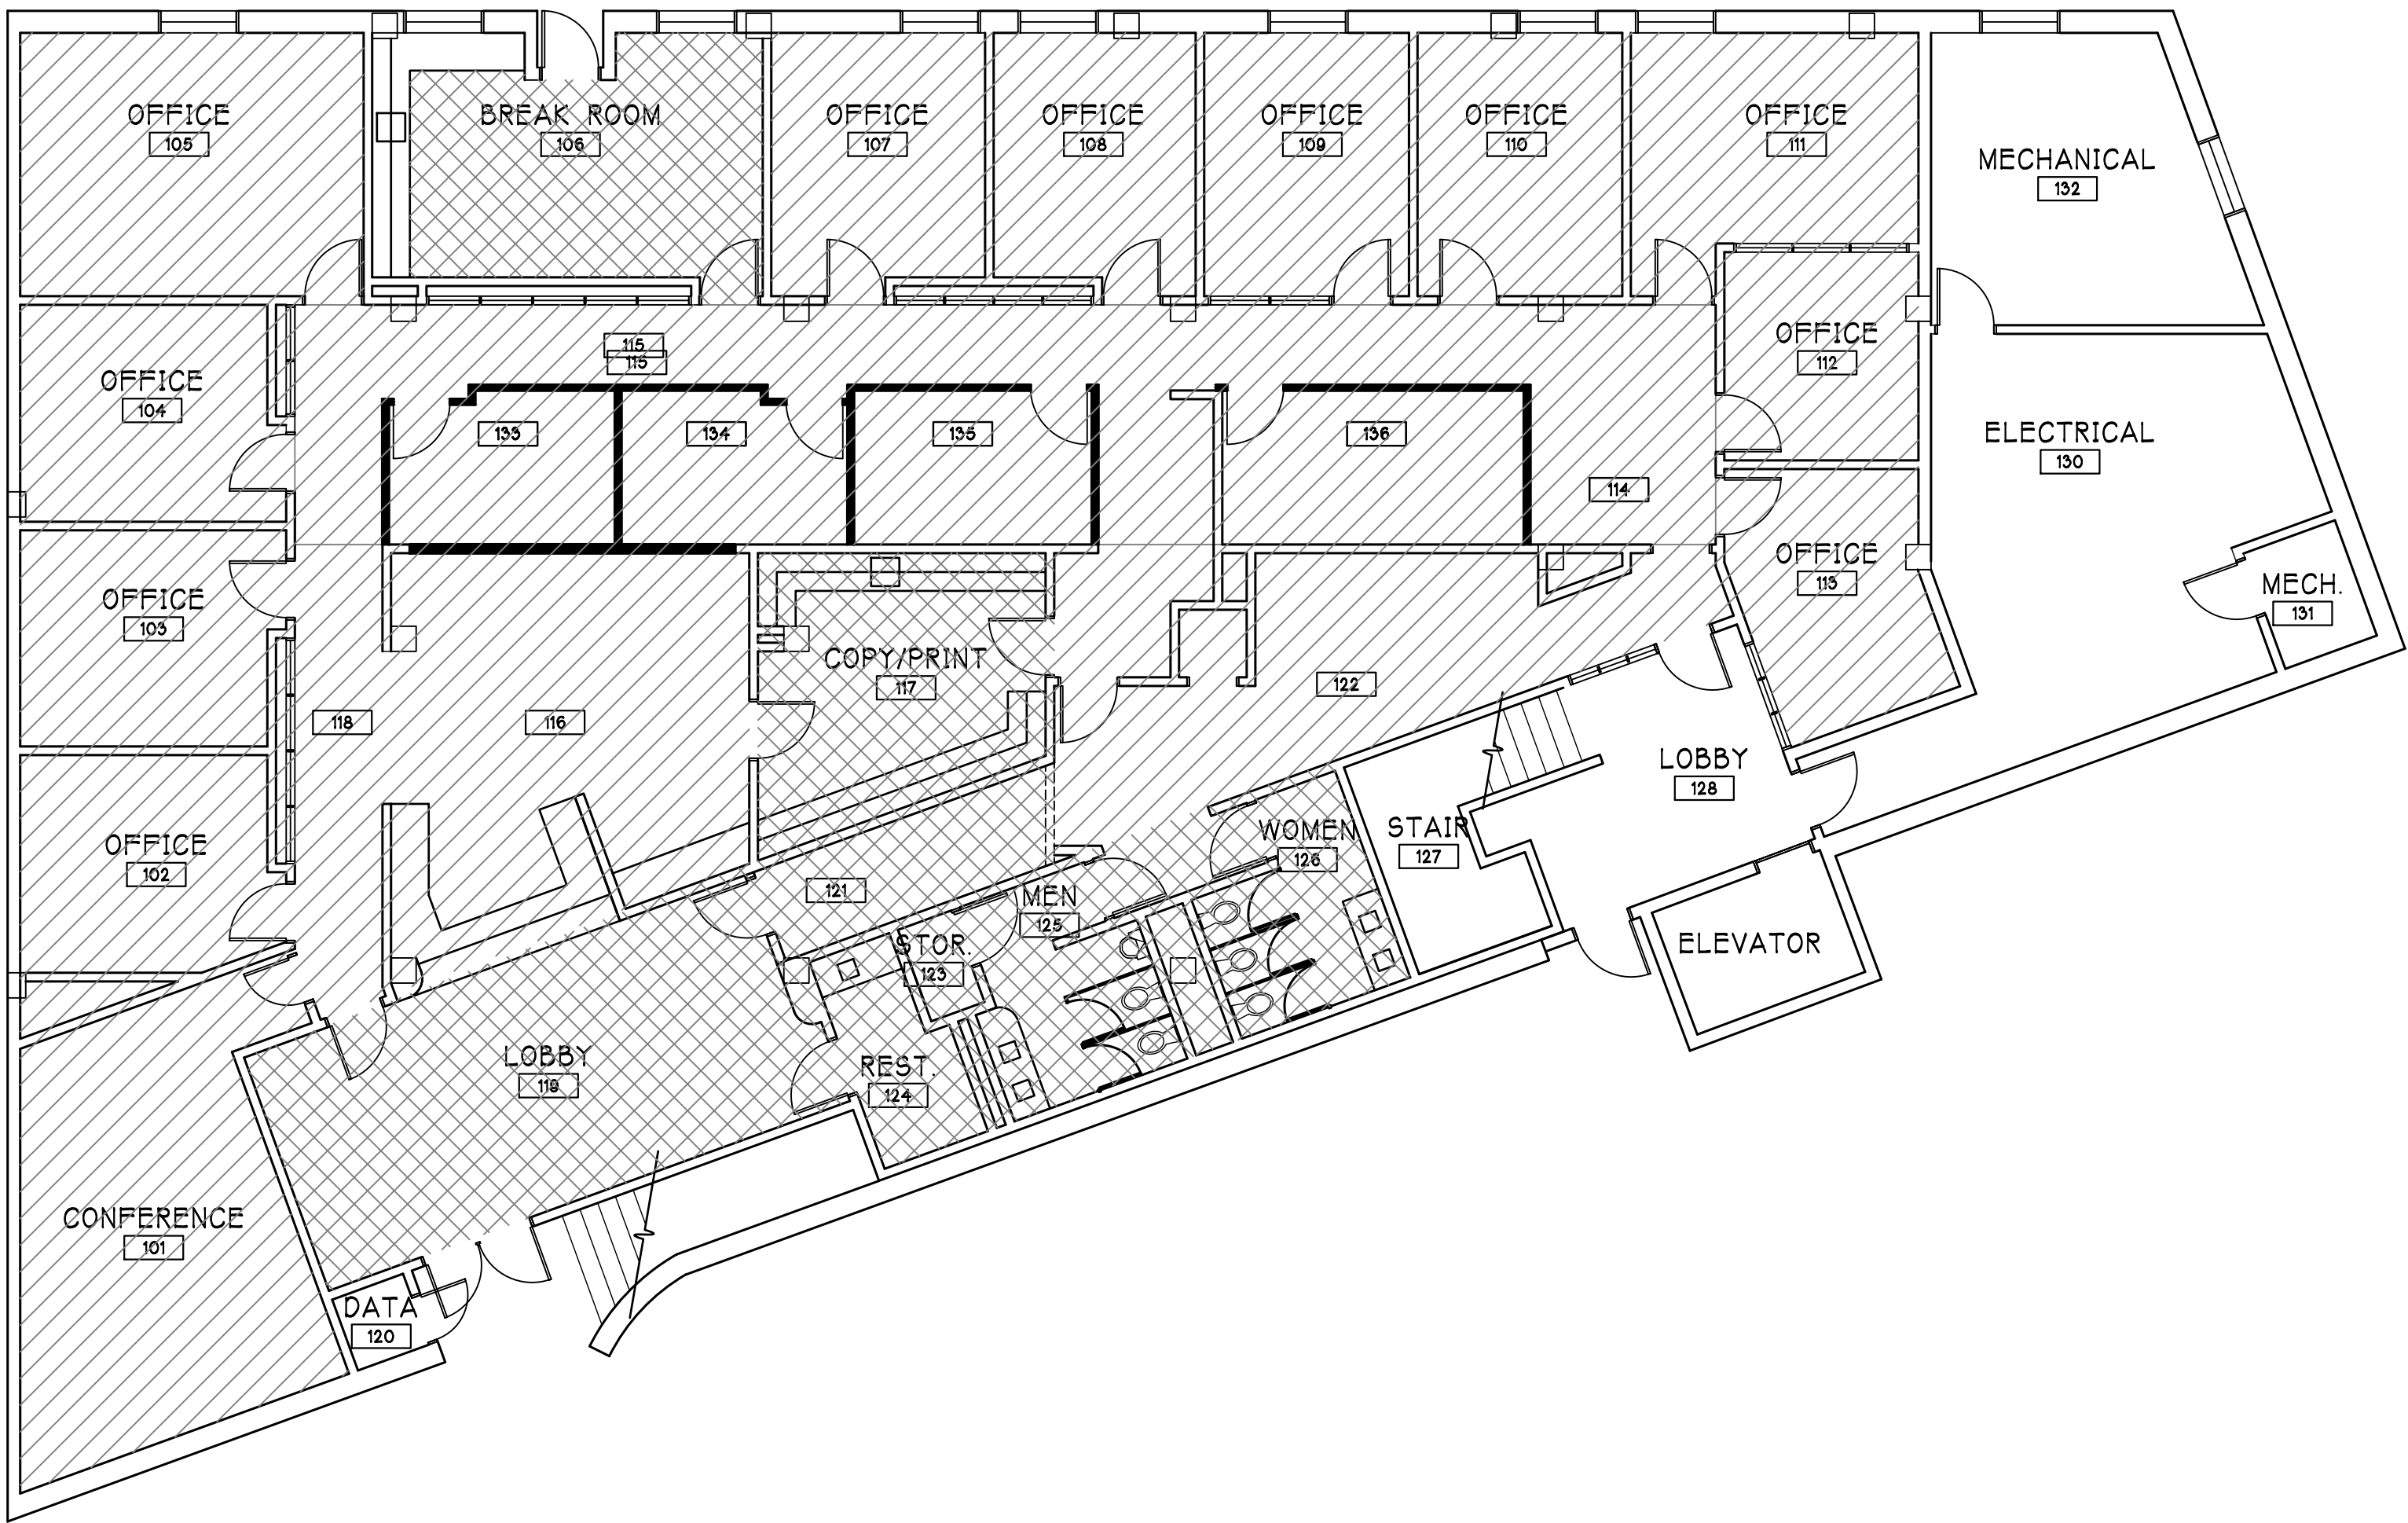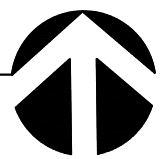

FLOOR FINISH PLAN


1/8"=1'-0"

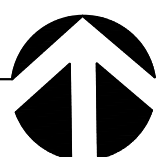

**CARLETTI ARCHITECTS P.S.**  
architecture, planning, interior design

116 EAST FIR STREET  
SUITE A  
MOUNT VERNON, WA. 98273

Phone: (360) 424-0394  
Fax: (360) 424-5726

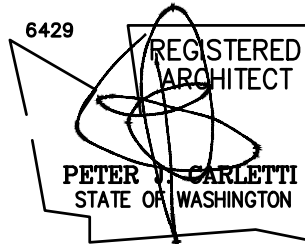

SKAGIT COUNTY COURTHOUSE  
ANNEX FIRST FLOOR  
T.I.  
605 SOUTH THIRD STREET  
MOUNT VERNON, WA 98273

CLIENT CONTACT: KEN HANSEN  
PHONE: 360-416-1179  
EMAIL: khansen@co.skagit.wa.us

PROJECT# 24-821  
PROJECT NUMBER:

REVISIONS: 1  
05/15/25 BID SET

SHEET TITLE:

KEY PLAN

FLOOR FINISH PLAN

PJC  
PROJECT ARCHITECT:

IC  
DRAWN BY:

PJC  
CHECKED BY:


SEPTEMBER 17, 2024  
DATE

24-821 SC ANNEX OFFICE BASE  
COMPUTER FILE NAME

A-2.1

COPYRIGHT 2024 CARLETTI ARCHITECTS, P.S.



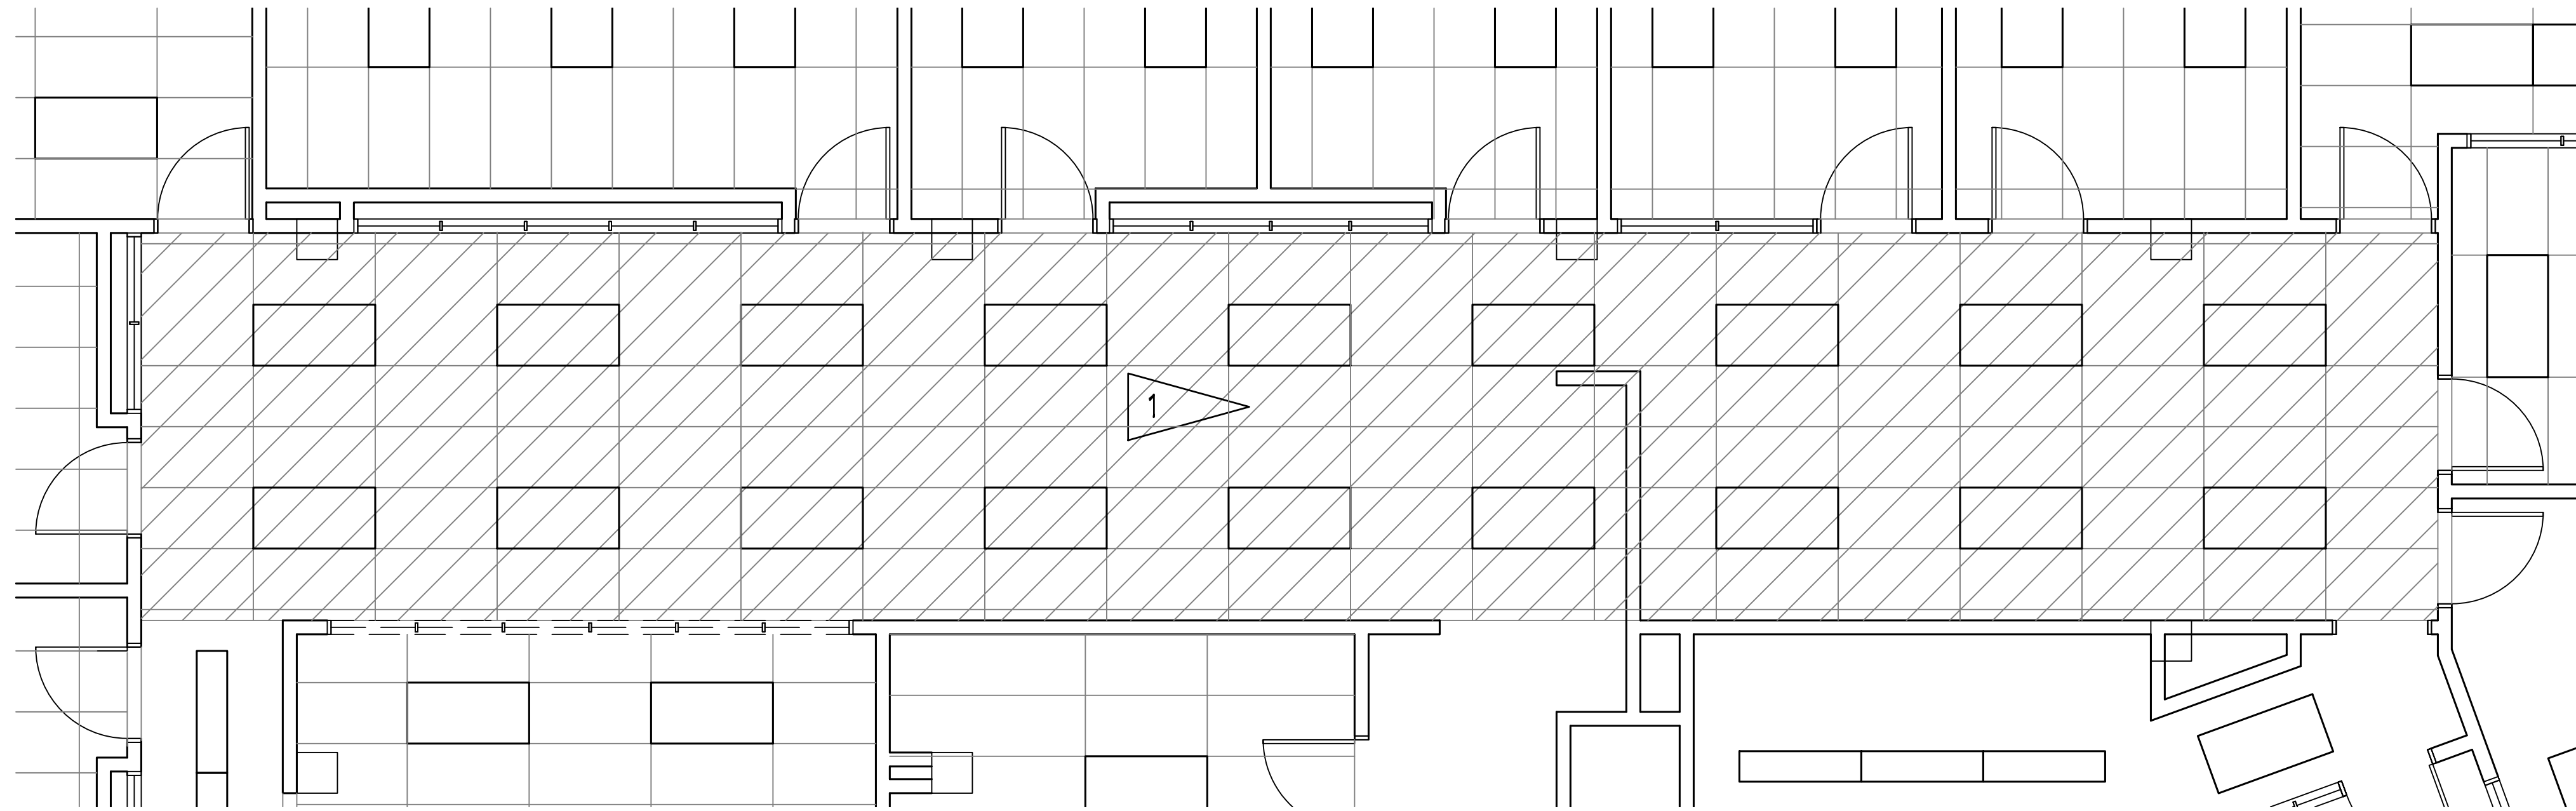


REFLECTED CEILING PLAN DEMOLITION NOTES:

1 REMOVE SUSPENDED ACOUSTICAL CEILING TILE AND LIGHT FIXTURES AND MISCELLANEOUS HVAC ITEMS THIS AREA.

**CARLETTI ARCHITECTS P.S.**  
architecture, planning, interior design



116 EAST FIR STREET  
SUITE A  
MOUNT VERNON, WA. 98273

Phone: (360) 424-0394  
Fax: (360) 424-5726

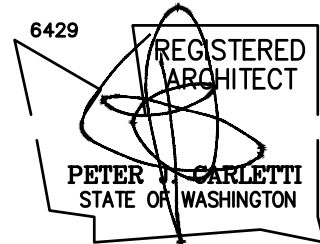

SKAGIT COUNTY COURTHOUSE  
ANNEX FIRST FLOOR  
T.I.  
605 SOUTH THIRD STREET  
MOUNT VERNON, WA 98273

3 REFLECTED CEILING PLAN DEMOLITION

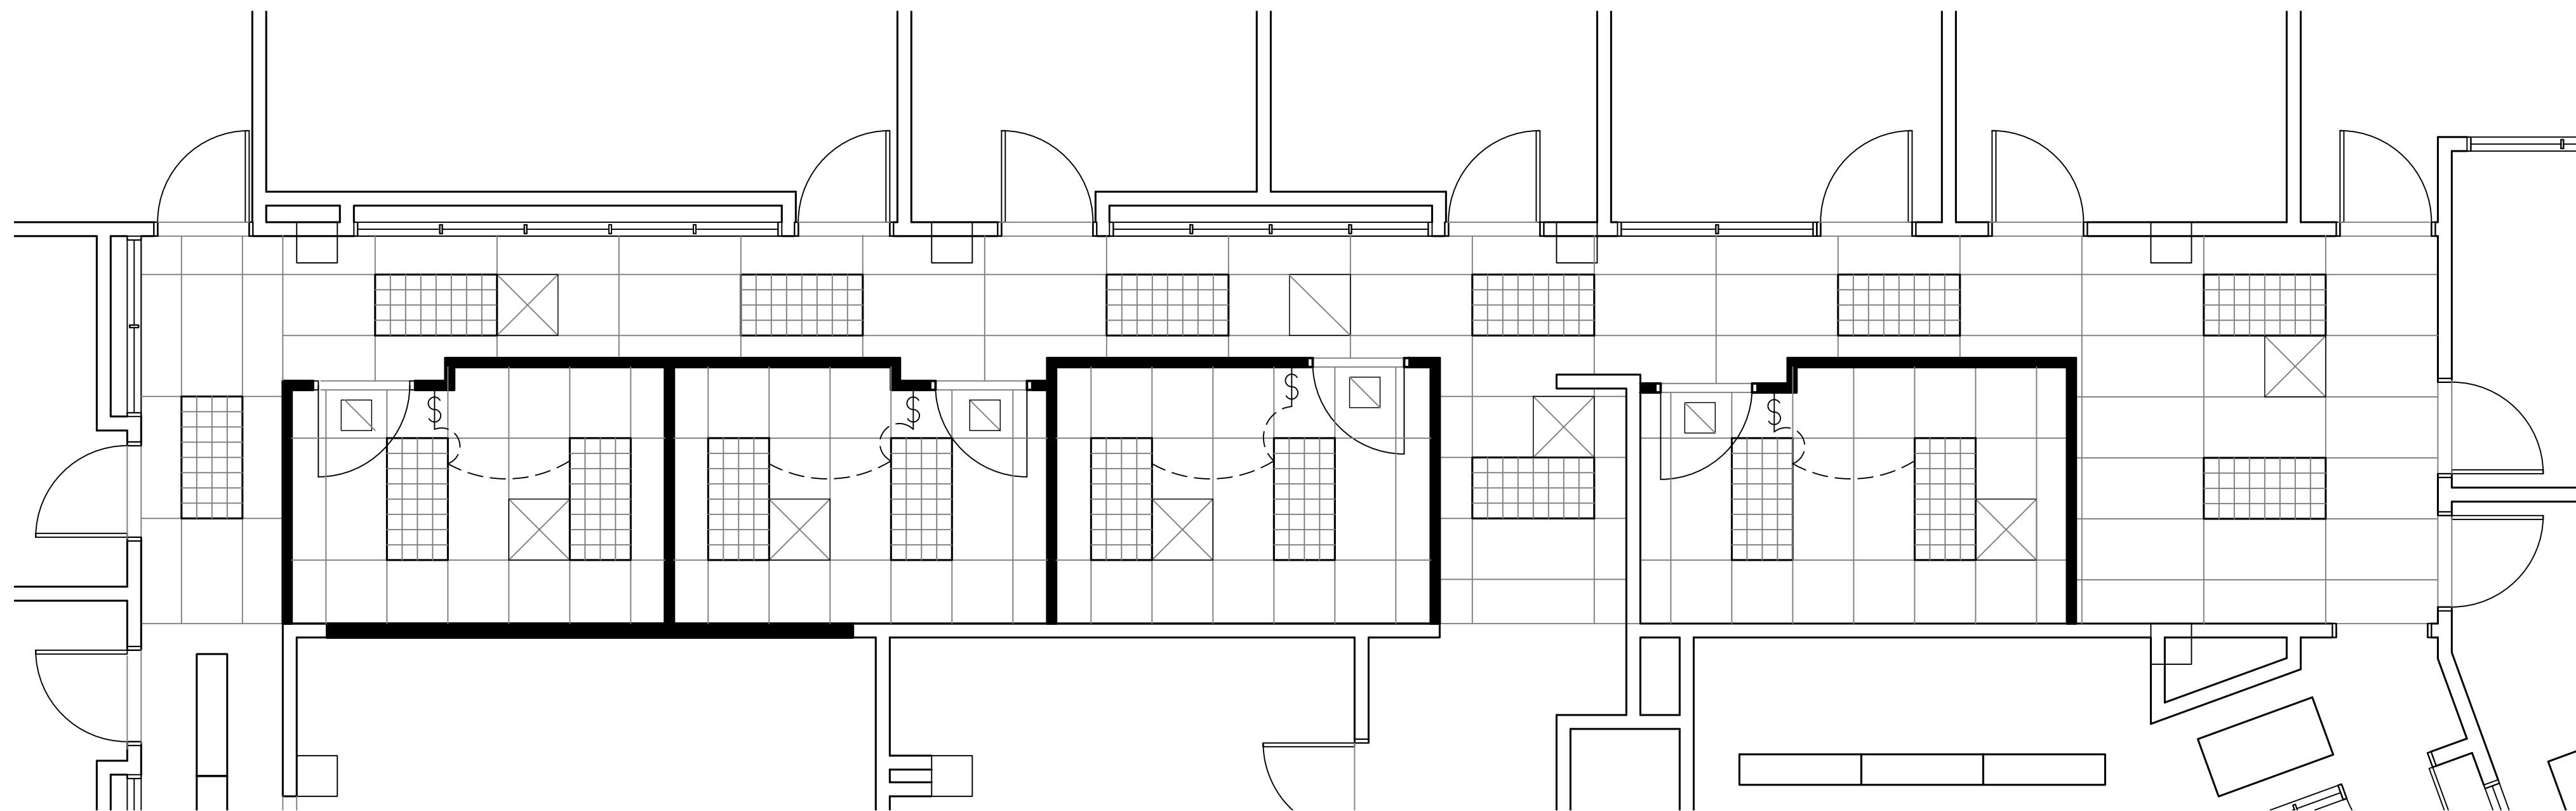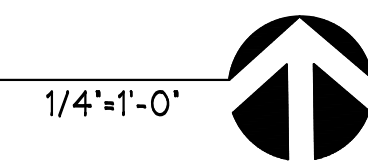

PROPOSED REFLECTED CEILING PLAN NOTES:

INDICATES NEW LIGHTING FIXTURE IN SUSPENDED CEILING.

INDICATES NEW SUSPENDED ACOUSTICAL CEILING TILE AT 8'-6" AFF.

INDICATES HVAC SUPPLY.



INDICATES HVAC RETURN.

CLIENT CONTACT: KEN HANSEN  
PHONE: 360-416-1179  
EMAIL: khansen@co.skagit.wa.us

PROJECT# 24-821  
PROJECT NUMBER:

| REVISIONS.       |
|------------------|
| 1                |
| 05/15/25 BID SET |
|                  |
|                  |
2 PROPOSED REFLECTED CEILING PLAN

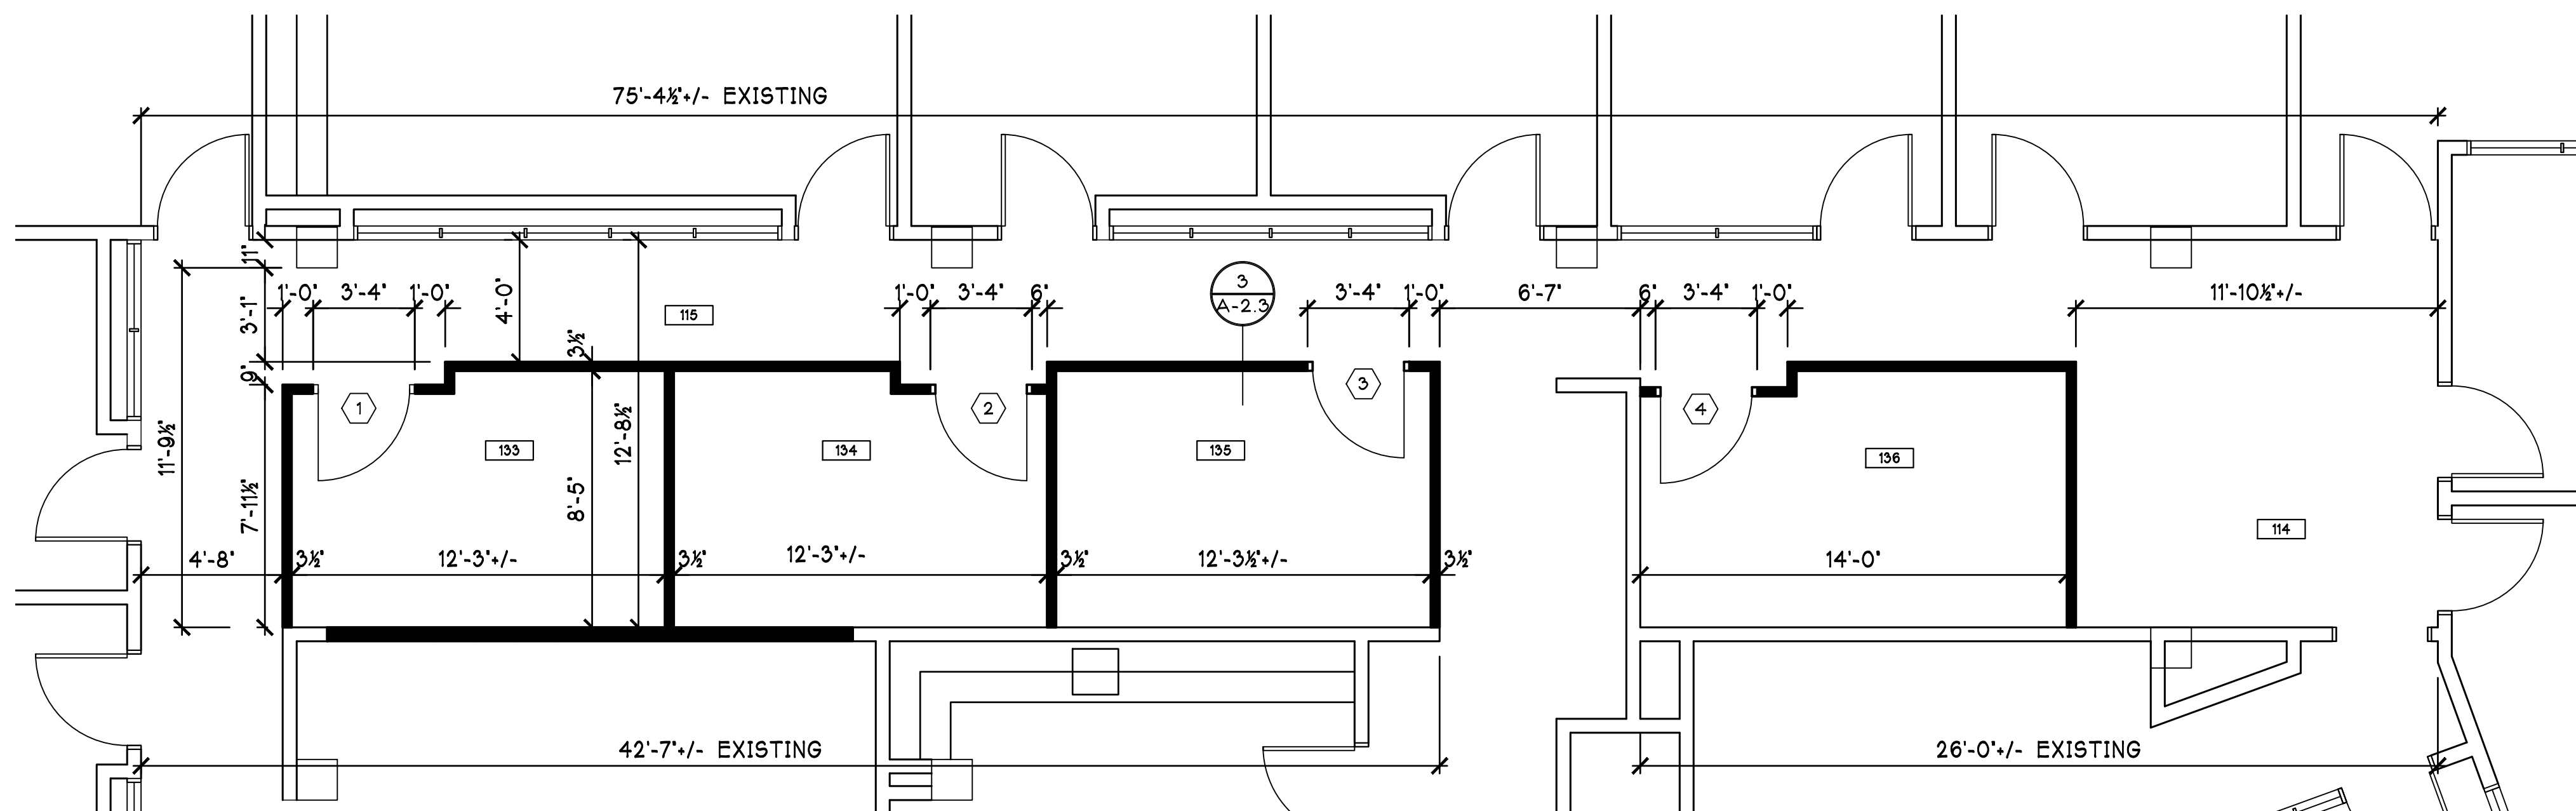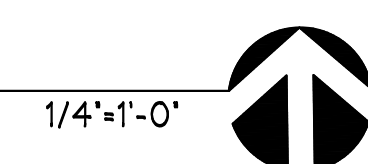

PROPOSED FLOOR PLAN NOTES:

TYPICALLY INDICATES 3 5/8" STEEL STUDS, 30 MIL. AT 16" O.C. WITH 5/8" TYPE 'X' GWB EACH SIDE. WALLS TYPICALLY TO GO UNDERSIDE OF STRUCTURE ABOVE AND FILLED WITH ACOUSTICAL BATTS. SEE DETAIL SHEET A2.3.

SEE DOOR SCHEDULE.

ROOM NUMBER, SEE FINISH SCHEDULE.

SHEET TITLE:

REFLECTED CEILING

DEMOLITION PLAN

PROPOSED FLOOR PLAN

PROPOSED REFLECTED CEILING

PLAN

PJC  
PROJECT ARCHITECT:


IC  
DRAWN BY:

PJC  
CHECKED BY:

SEPTEMBER 17, 2024  
DATE

24-821 SC ANNEX OFFICE BASE  
COMPUTER FILE NAME

1 PROPOSED FLOOR PLAN

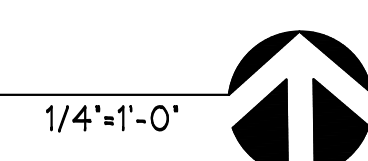

A-2.2






CARLETTI ARCHITECTS P.S.  
architecture, planning, interior design

116 EAST FIR STREET  
SUITE A  
MOUNT VERNON, WA. 98273

Phone: (360) 424-0394  
Fax: (360) 424-5726

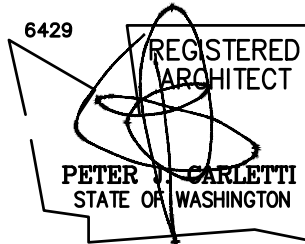

SKAGIT COUNTY COURTHOUSE  
ANNEX FIRST FLOOR  
T.I.  
605 SOUTH THIRD STREET  
MOUNT VERNON, WA 98273

CLIENT CONTACT: KEN HANSEN  
PHONE: 360-416-1179  
EMAIL: khansen@co.skagit.wa.us

PROJECT# 24-821  
PROJECT NUMBER:

REVISIONS: 1  
05/15/25 BID SET

SHEET TITLE:

MECHANICAL PLAN

ELECTRICAL AND TELE-DATA

PLAN

WALL SECTION

PJC  
PROJECT ARCHITECT:

IC  
DRAWN BY:


PJC  
CHECKED BY:

SEPTEMBER 17, 2024  
DATE

24-821 SC ANNEX OFFICE BASE  
COMPUTER FILE NAME

A-2.3

COPYRIGHT 2024 CARLETTI ARCHITECTS. P.S.

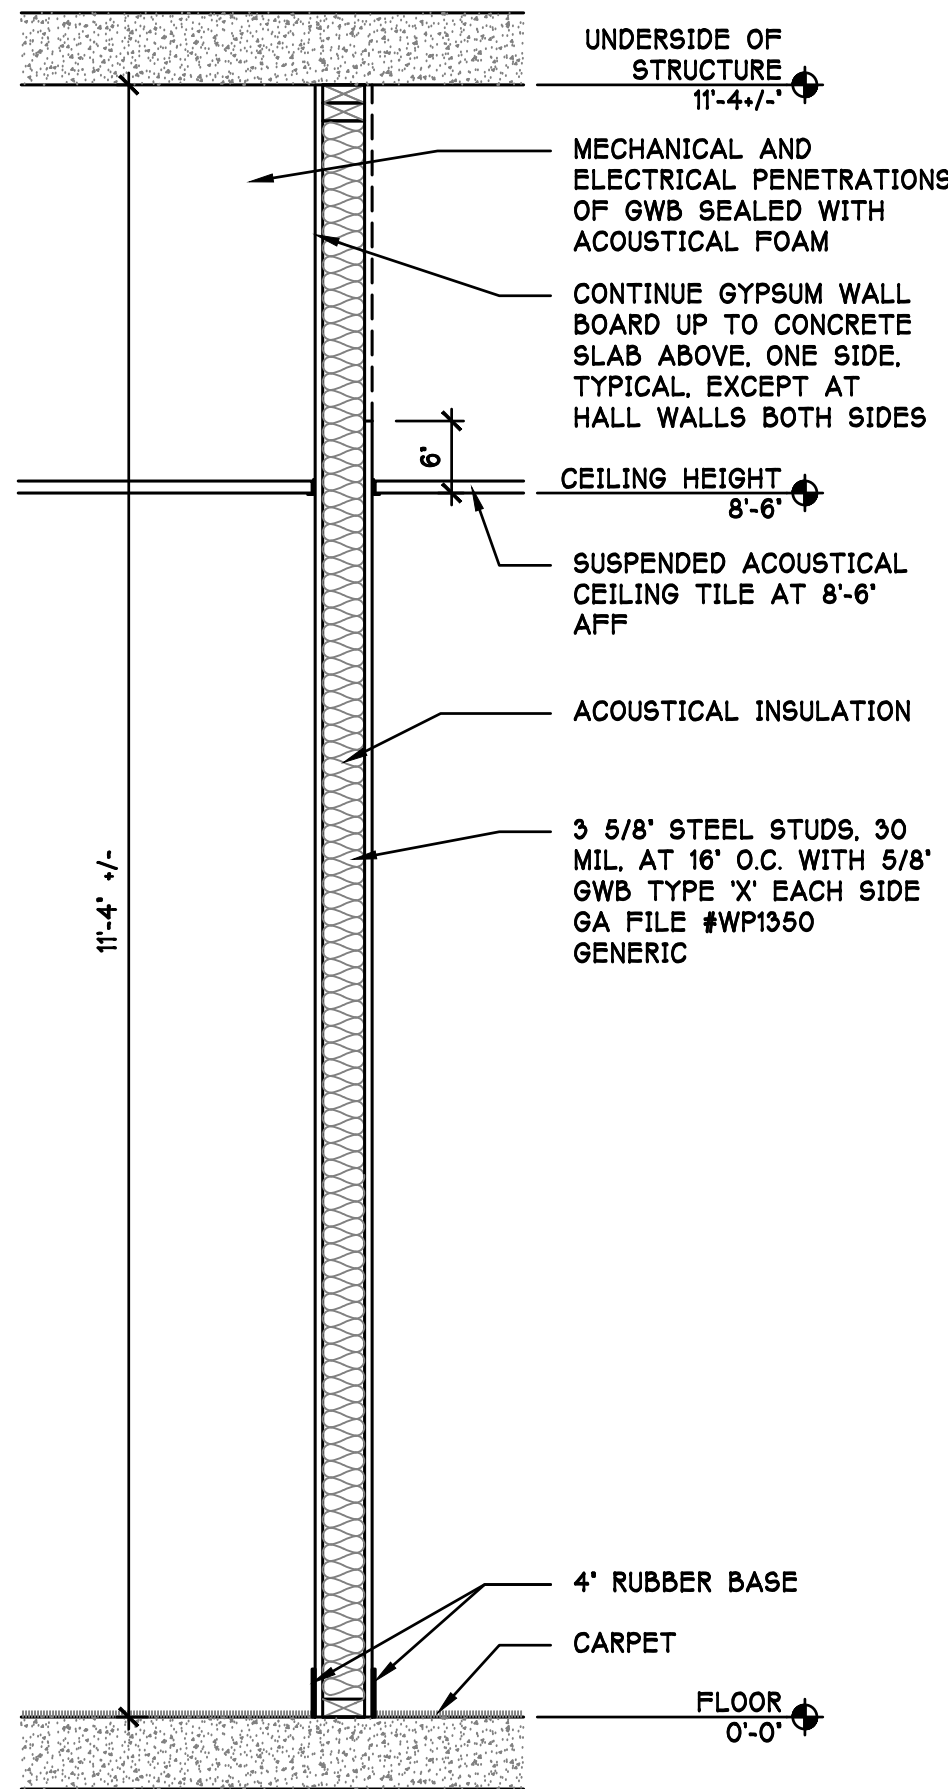

3 WALL SECTION


3/4"=1'-0"

MECHANICAL PLAN NOTES:

- INDICATES ITEMS TO BE REMOVED OR RELOCATED IF POSSIBLE.
- INDICATES EXISTING SUPPLY. RELOCATE AS SHOWN OR IF NECESSARY TO FIT NEW CEILING LAYOUT.
- INDICATES NEW 24X24 SUPPLY WITH DUCTWORK TO EXISTING TRUNK. SEE REFLECTED CEILING PLAN.
- INDICATES EXISTING TRANSFER GRILLE TO PLENUM RETURN. RELOCATE AS INDICATED. SEE REFLECTED CEILING PLAN.
- INDICATES NEW TRANSFER GRILLE.


ELECTRICAL AND TELE-DATA PLAN NOTES:

- LIGHT SWITCH.
- INDICATES DUPLEX RECEPTACLE.
- INDICATES MUD RING WITH 3/4" PIPE TO ACCESSIBLE CEILING. INCLUDE PULL STRING.
- SEE SHEET A-2.0, LIFE SAFETY PLAN, FOR WORK REGARDING EXIT LIGHTS AND EMERGENCY LIGHTING.
- SEE SHEET A-S.0, LIFE SAFETY PLAN FOR NOTE REGARDING BIDDER DESIGN FIRE ALARM MODIFICATIONS.

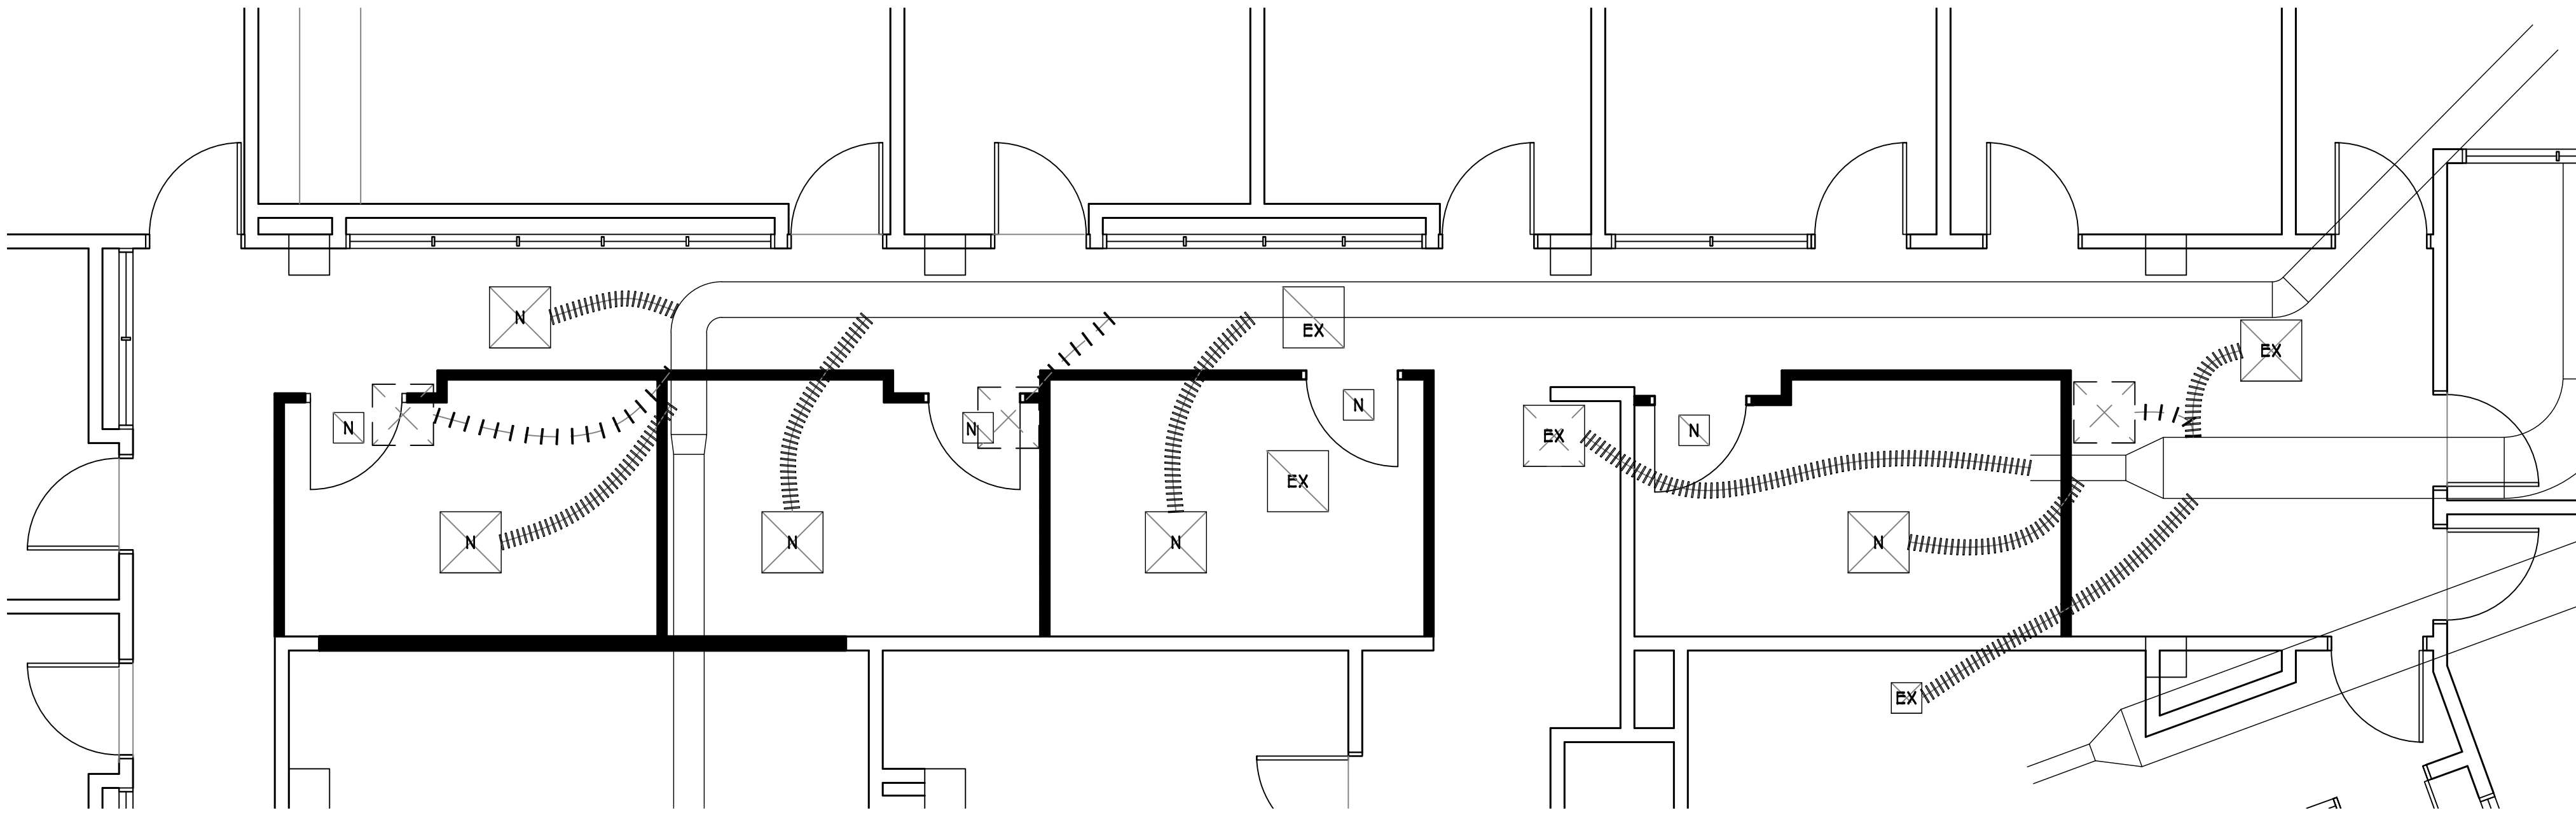

2 MECHANICAL PLAN

1/4"=1'-0"

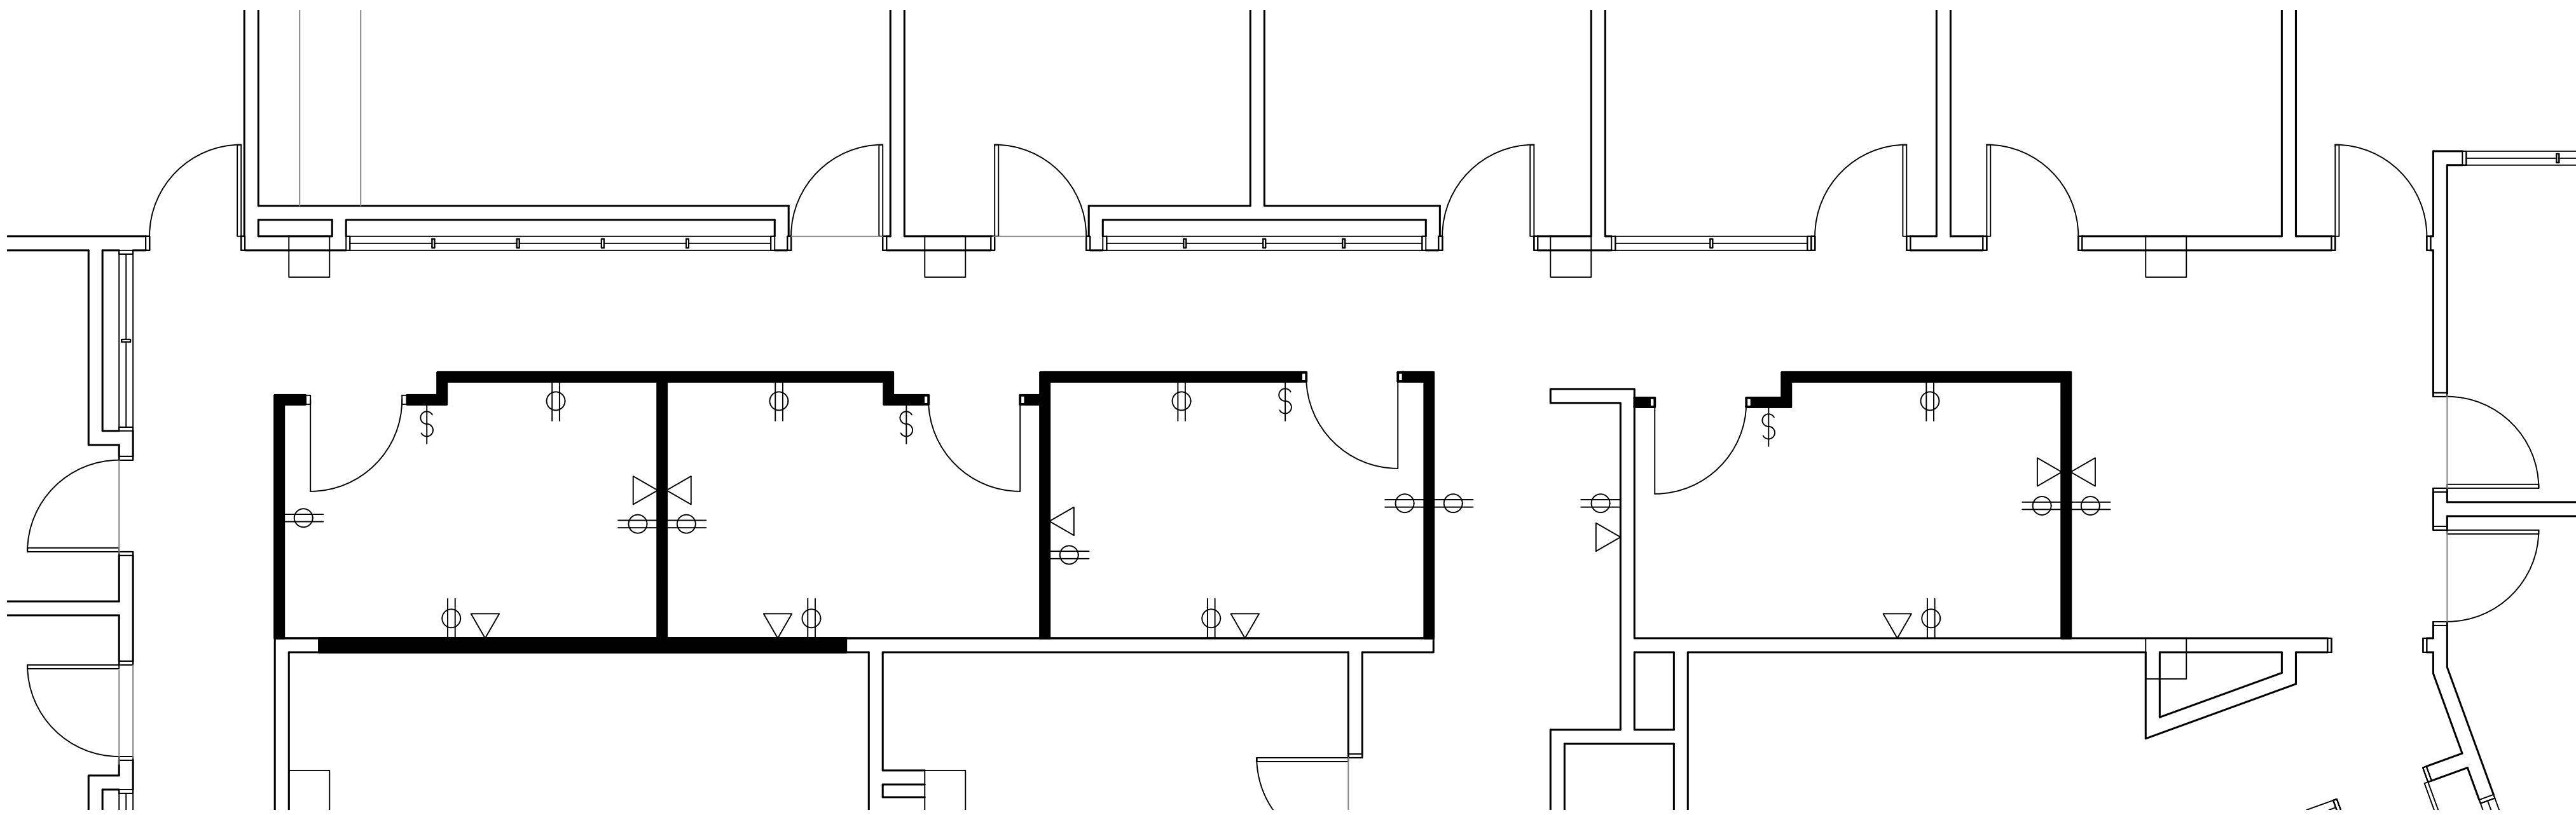

1 ELECTRICAL AND TELE-DATA PLAN


1/4"=1'-0"





116 EAST FIR STREET  
SUITE A  
MOUNT VERNON, WA. 98273

Phone: (360) 424-0394  
Fax: (360) 424-5726

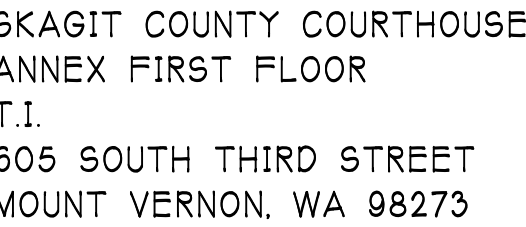

CLIENT CONTACT: KEN HANSEN  
PHONE: 360-416-1179  
EMAIL: khansen@co.skgagit.wa.us

|                                     | FLOOR  |      |      | BASE  |      |      | NORTH WALL |      |      | SOUTH WALL |      |      | EAST WALL |      |      | WEST WALL |      |      | CEILING |      |      | NOTES |
|-------------------------------------|--------|------|------|-------|------|------|------------|------|------|------------|------|------|-----------|------|------|-----------|------|------|---------|------|------|-------|
|                                     | MAT'L  | FIN. | NOTE | MAT'L | FIN. | NOTE | MAT'L      | FIN. | NOTE | MAT'L      | FIN. | NOTE | MAT'L     | FIN. | NOTE | MAT'L     | FIN. | NOTE | MAT'L   | FIN. | NOTE |       |
| CONFERENCE                          | CARPET | FF   |      | VRB   | FF   |      | EXGWB      | PNT  |      | EXGWB      | PNT  |      | EXGWB     | PNT  |      | EXGWB     | PNT  |      | NO WORK |      |      |       |
| OFFICE                              | CARPET | FF   |      | VRB   | FF   |      | EXGWB      | PNT  |      | EXGWB      | PNT  |      | EXGWB     | PNT  |      | EXGWB     | PNT  |      | NO WORK |      |      |       |
| OFFICE                              | CARPET | FF   |      | VRB   | FF   |      | EXGWB      | PNT  |      | EXGWB      | PNT  |      | EXGWB     | PNT  |      | EXGWB     | PNT  |      | NO WORK |      |      |       |
| OFFICE                              | CARPET | FF   |      | VRB   | FF   |      | EXGWB      | PNT  |      | EXGWB      | PNT  |      | EXGWB     | PNT  |      | EXGWB     | PNT  |      | NO WORK |      |      |       |
| BREAK ROOM                          | LVT    | FF   |      | VRB   | FF   |      | EXGWB      | PNT  |      | EXGWB      | PNT  |      | EXGWB     | PNT  |      | EXGWB     | PNT  |      | NO WORK |      |      |       |
| OFFICE                              | CARPET | FF   |      | VRB   | FF   |      | EXGWB      | PNT  |      | EXGWB      | PNT  |      | EXGWB     | PNT  |      | EXGWB     | PNT  |      | NO WORK |      |      |       |
| OFFICE                              | CARPET | FF   |      | VRB   | FF   |      | EXGWB      | PNT  |      | EXGWB      | PNT  |      | EXGWB     | PNT  |      | EXGWB     | PNT  |      | NO WORK |      |      |       |
| OFFICE                              | CARPET | FF   |      | VRB   | FF   |      | EXGWB      | PNT  |      | EXGWB      | PNT  |      | EXGWB     | PNT  |      | EXGWB     | PNT  |      | NO WORK |      |      |       |
| OFFICE                              | CARPET | FF   |      | VRB   | FF   |      | EXGWB      | PNT  |      | EXGWB      | PNT  |      | EXGWB     | PNT  |      | EXGWB     | PNT  |      | NO WORK |      |      |       |
| OFFICE                              | CARPET | FF   |      | VRB   | FF   |      | EXGWB      | PNT  |      | EXGWB      | PNT  |      | EXGWB     | PNT  |      | EXGWB     | PNT  |      | NO WORK |      |      |       |
| HALL                                | CARPET | FF   |      | VRB   | FF   |      | GWB        | PNT  |      | GWB        | PNT  |      | GWB       | PNT  |      | GWB       | PNT  |      | SACT    |      | FF   |       |
| HALL                                | CARPET | FF   |      | VRB   | FF   |      | GWB        | PNT  |      | GWB        | PNT  |      | GWB       | PNT  |      | GWB       | PNT  |      | SACT    |      | FF   |       |
| RECEPTION                           | CARPET | FF   |      | VRB   | FF   |      | EXGWB      | PNT  |      | EXGWB      | PNT  |      | EXGWB     | PNT  |      | EXGWB     | PNT  |      | NO WORK |      |      |       |
| BREAK ROOM                          | LVT    | FF   |      | VRB   | FF   |      | EXGWB      | PNT  |      | EXGWB      | PNT  |      | EXGWB     | PNT  |      | EXGWB     | PNT  |      | NO WORK |      |      |       |
| HALL                                | CARPET | FF   |      | VRB   | FF   |      | EXGWB      | PNT  |      | EXGWB      | PNT  |      | EXGWB     | PNT  |      | EXGWB     | PNT  |      | NO WORK |      |      |       |
| LOBBY/<br>STORAGE                   | LVT    | FF   |      | VRB   | FF   |      | EXGWB      | PNT  |      | EXGWB      | PNT  |      | EXGWB     | PNT  |      | EXGWB     | PNT  |      | NO WORK |      |      |       |
| HALL                                | CARPET | FF   |      | VRB   | FF   |      | EXGWB      | PNT  |      | EXGWB      | PNT  |      | EXGWB     | PNT  |      | EXGWB     | PNT  |      | NO WORK |      |      |       |
| HALL                                | CARPET | FF   |      | VRB   | FF   |      | EXGWB      | PNT  |      | EXGWB      | PNT  |      | EXGWB     | PNT  |      | EXGWB     | PNT  |      | NO WORK |      |      |       |
| STORAGE                             |        |      | RESTROOM                            | LVT    | FF   |      | VRB   | FF   |      | 1 EXGWB    | PNT  |      | EXGWB      | PNT  |      | EXGWB     | PNT  |      | EXGWB     | PNT  |      | NO WORK |      |      |       |
| RESTROOM                            | LVT    | FF   |      | VRB   | FF   |      | 1 EXGWB    | PNT  |      | EXGWB      | PNT  |      | EXGWB     | PNT  |      | EXGWB     | PNT  |      | NO WORK |      |      |       |
| RESTROOM                            | LVT    | FF   |      | VRB   | FF   |      | 1 EXGWB    | PNT  |      | EXGWB      | PNT  |      | EXGWB     | PNT  |      | EXGWB     | PNT  |      | NO WORK |      |      |       |
| STAIR                               |        |      |      | VRB   | FF   |      | EXGWB      | PNT  |      | EXGWB      | PNT  |      | EXGWB     | PNT  |      | EXGWB     | PNT  |      | NO WORK |      |      |       |
| LOBBY/<br>ELEVATOR                  | LVT    | FF   |      | VRB   | FF   |      | EXGWB      | PNT  |      | EXGWB      | PNT  |      | EXGWB     | PNT  |      | EXGWB     | PNT  |      | NO WORK |      |      |       |
| UTILITY<br>MECHANICAL<br>MECHANICAL |        |      | OFFICE                              | CARPET | FF   |      | VRB   | FF   |      | GWB        | PNT  |      | GWB        | PNT  |      | GWB       | PNT  |      | GWB       | PNT  |      | SACT    |      | FF   |       |
| OFFICE                              | CARPET | FF   |      | VRB   | FF   |      | GWB        | PNT  |      | GWB        | PNT  |      | GWB       | PNT  |      | GWB       | PNT  |      | SACT    |      | FF   |       |
| OFFICE                              | CARPET | FF   |      | VRB   | FF   |      | GWB        | PNT  |      | GWB        | PNT  |      | GWB       | PNT  |      | GWB       | PNT  |      | SACT    |      | FF   |       |
| OFFICE                              | CARPET | FF   |      | VRB   | FF   |      | GWB        |      |      |            |      |      |           |      |      |           |      |      |         |      |      |       |

All carpet to be 24 x 24, Shaw, Elevate 51388, Filter 88596  
All base to be Roppe 700 Series 4" Cove, Color, 123 Charcoal  
All paint to be Sherwin Williams, Satin, Navaho White, SW 6126  
All new ceilings to be Armstrong, Mesa, 2nd Look I, White with White grid, 15/16 inch Angled Trough #688 or Approved Equivalent  
All LVT to be 8" x 50" Shaw 4499V Pivot, 00115 Mindset

[illegible]

PJC  
PROJECT ARCHITECT:

C  
DRAWN BY:

PJC  
CHECKED BY:

SEPTEMBER 17, 2024  
DATE

24-821 SC ANNEX OFFICE BAS  
COMPUTER FILE NAME

A-2.4